


MINISTRY OF RURAL & MARITIME DEVELOPMENT AND DISASTER MANAGEMENT

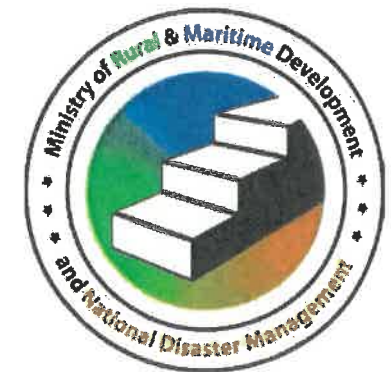


RURAL HOUSING ASSISTANCE UNIT



**STANDARD 7.2m X 4.8m OPEN DESIGN TIMBER FRAMED HOUSE
WITH 2.9m X 2.2m TOILET, BATHROOM & 2.9m
X 1.2m LAUNDRY AREA.**

DISCLAIMER

ALL DUE CARE AND RESPONSIBILITY MUST BE TAKEN WHILE USING THIS PLAN FOR ITS PURPOSE, AND IT SHOULD BE USED WHOLLY AND NOT PARTLY INCLUDING ARCHITECTURAL AND STRUCTURAL DETAILS AND CONNECTIONS. THE MINISTRY SHALL NOT BE LIABLE FOR ANY LOSSES OR DAMAGES ARISING FROM THE USE OF THIS DOCUMENT.

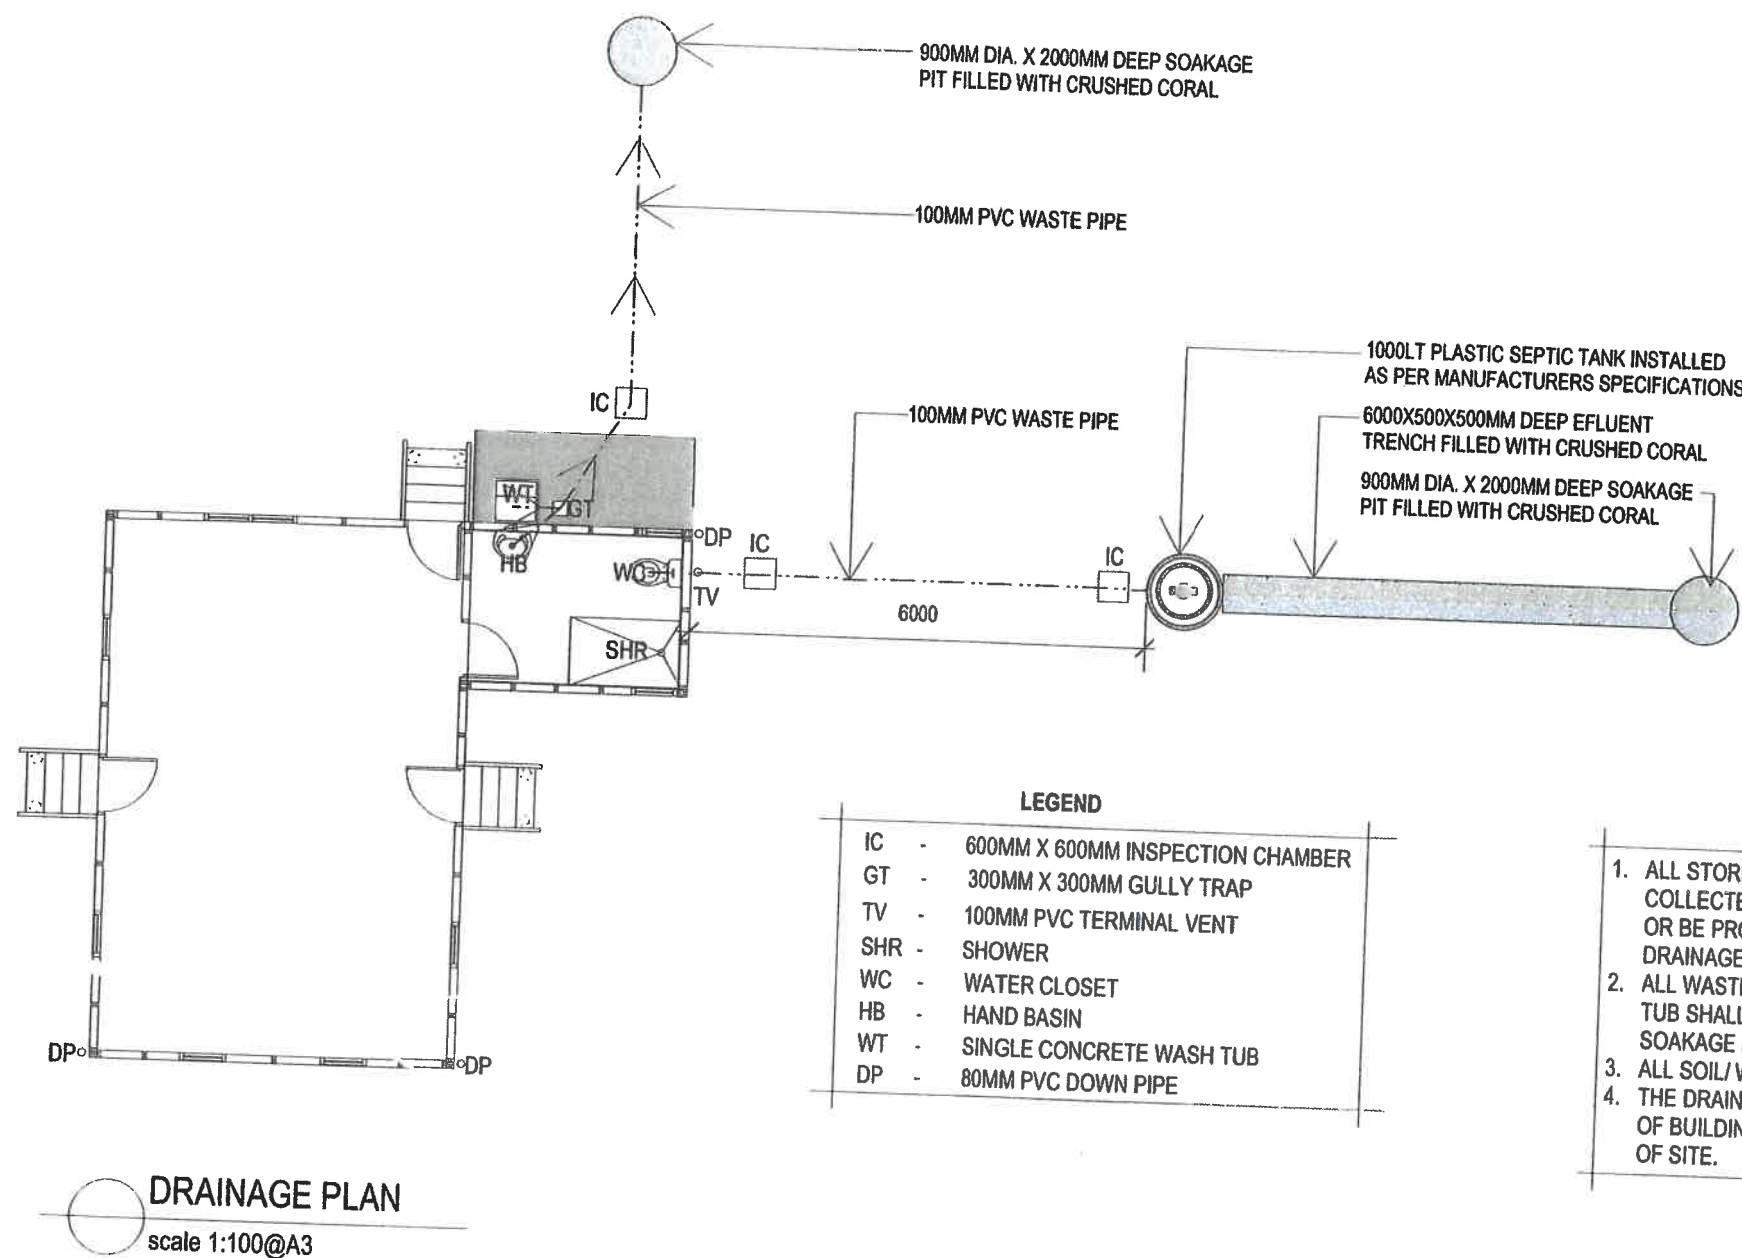

LEGEND	
IC	- 600MM X 600MM INSPECTION CHAMBER
GT	- 300MM X 300MM GULLY TRAP
TV	- 100MM PVC TERMINAL VENT
SHR	- SHOWER
WC	- WATER CLOSET
HB	- HAND BASIN
WT	- SINGLE CONCRETE WASH TUB
DP	- 80MM PVC DOWN PIPE

- NOTES**
1. ALL STORMWATER FROM ROOF SHALL BE EITHER COLLECTED AND STORED IN WATER TANKS (NOT PART OF SOW) OR BE PROPERLY DISCHARGED TO NEARBY STORMWATER DRAINAGE WITH OPEN CONC. 'V' DRAINS OR EARTH DRAINS.
 2. ALL WASTE WATER FROM SHOWER, HAND BASIN AND WASH TUB SHALL BE DISCHARGED TO 900MM DIA. X 2000MM DEEP SOAKAGE PIT FILLED WITH CRUSHED CORAL.
 3. ALL SOIL/ WASTE PIPE SHALL LAID TO 1:40 FALL
 4. THE DRAINAGE PLAN MAY VARY DEPENDING ON ORIENTATION OF BUILDING, SITE CONDITIONS OR TOPOGRAPHY LAYOUT OF SITE.

I have checked the structural components shown on the drawing and certify that they are adequate for their intended purpose.

ABHINE-SH CHAND (M.E. / 256)

Note:

1. The contractor/ builder shall notify the designer of any discrepancies prior to producing shop drawings and commencement of work on site.
2. All dimension's are in millimeter (mm). Figure dimensions shall take precedence over scaled dimensions and larger scale drawings shall take precedence over scaled drawings.
3. Copyright: Ministry of Rural & Maritime Development and Disaster Management. All Rights Reserved.



Project Title
Regional House
1 Knolly Street
P.O Box 2219
Govt. Bldg
Suva.


STANDARD 7.2m X 4.8m OPEN DESIGN TIMBER FRAMED HOUSE WITH 2.9m X 2.2m TOILET, BATHROOM & LAUNDRY AREA.

Ministry Of Rural & Maritime Development and Disaster Management
Rural Housing Assistance Unit

Phone: (679) 3313 400
Fax: (679) 3684 973
Suva.




Designed RHA	Checked HRHA	Date FEB' 2024	Drawing Title DRAINAGE PLAN	
Drawn RHA	Approved HRHA	Scale AS SHOWN	Drawing Reference No. 4/15/1/5-1(REV. 1)	Sheet No. A01

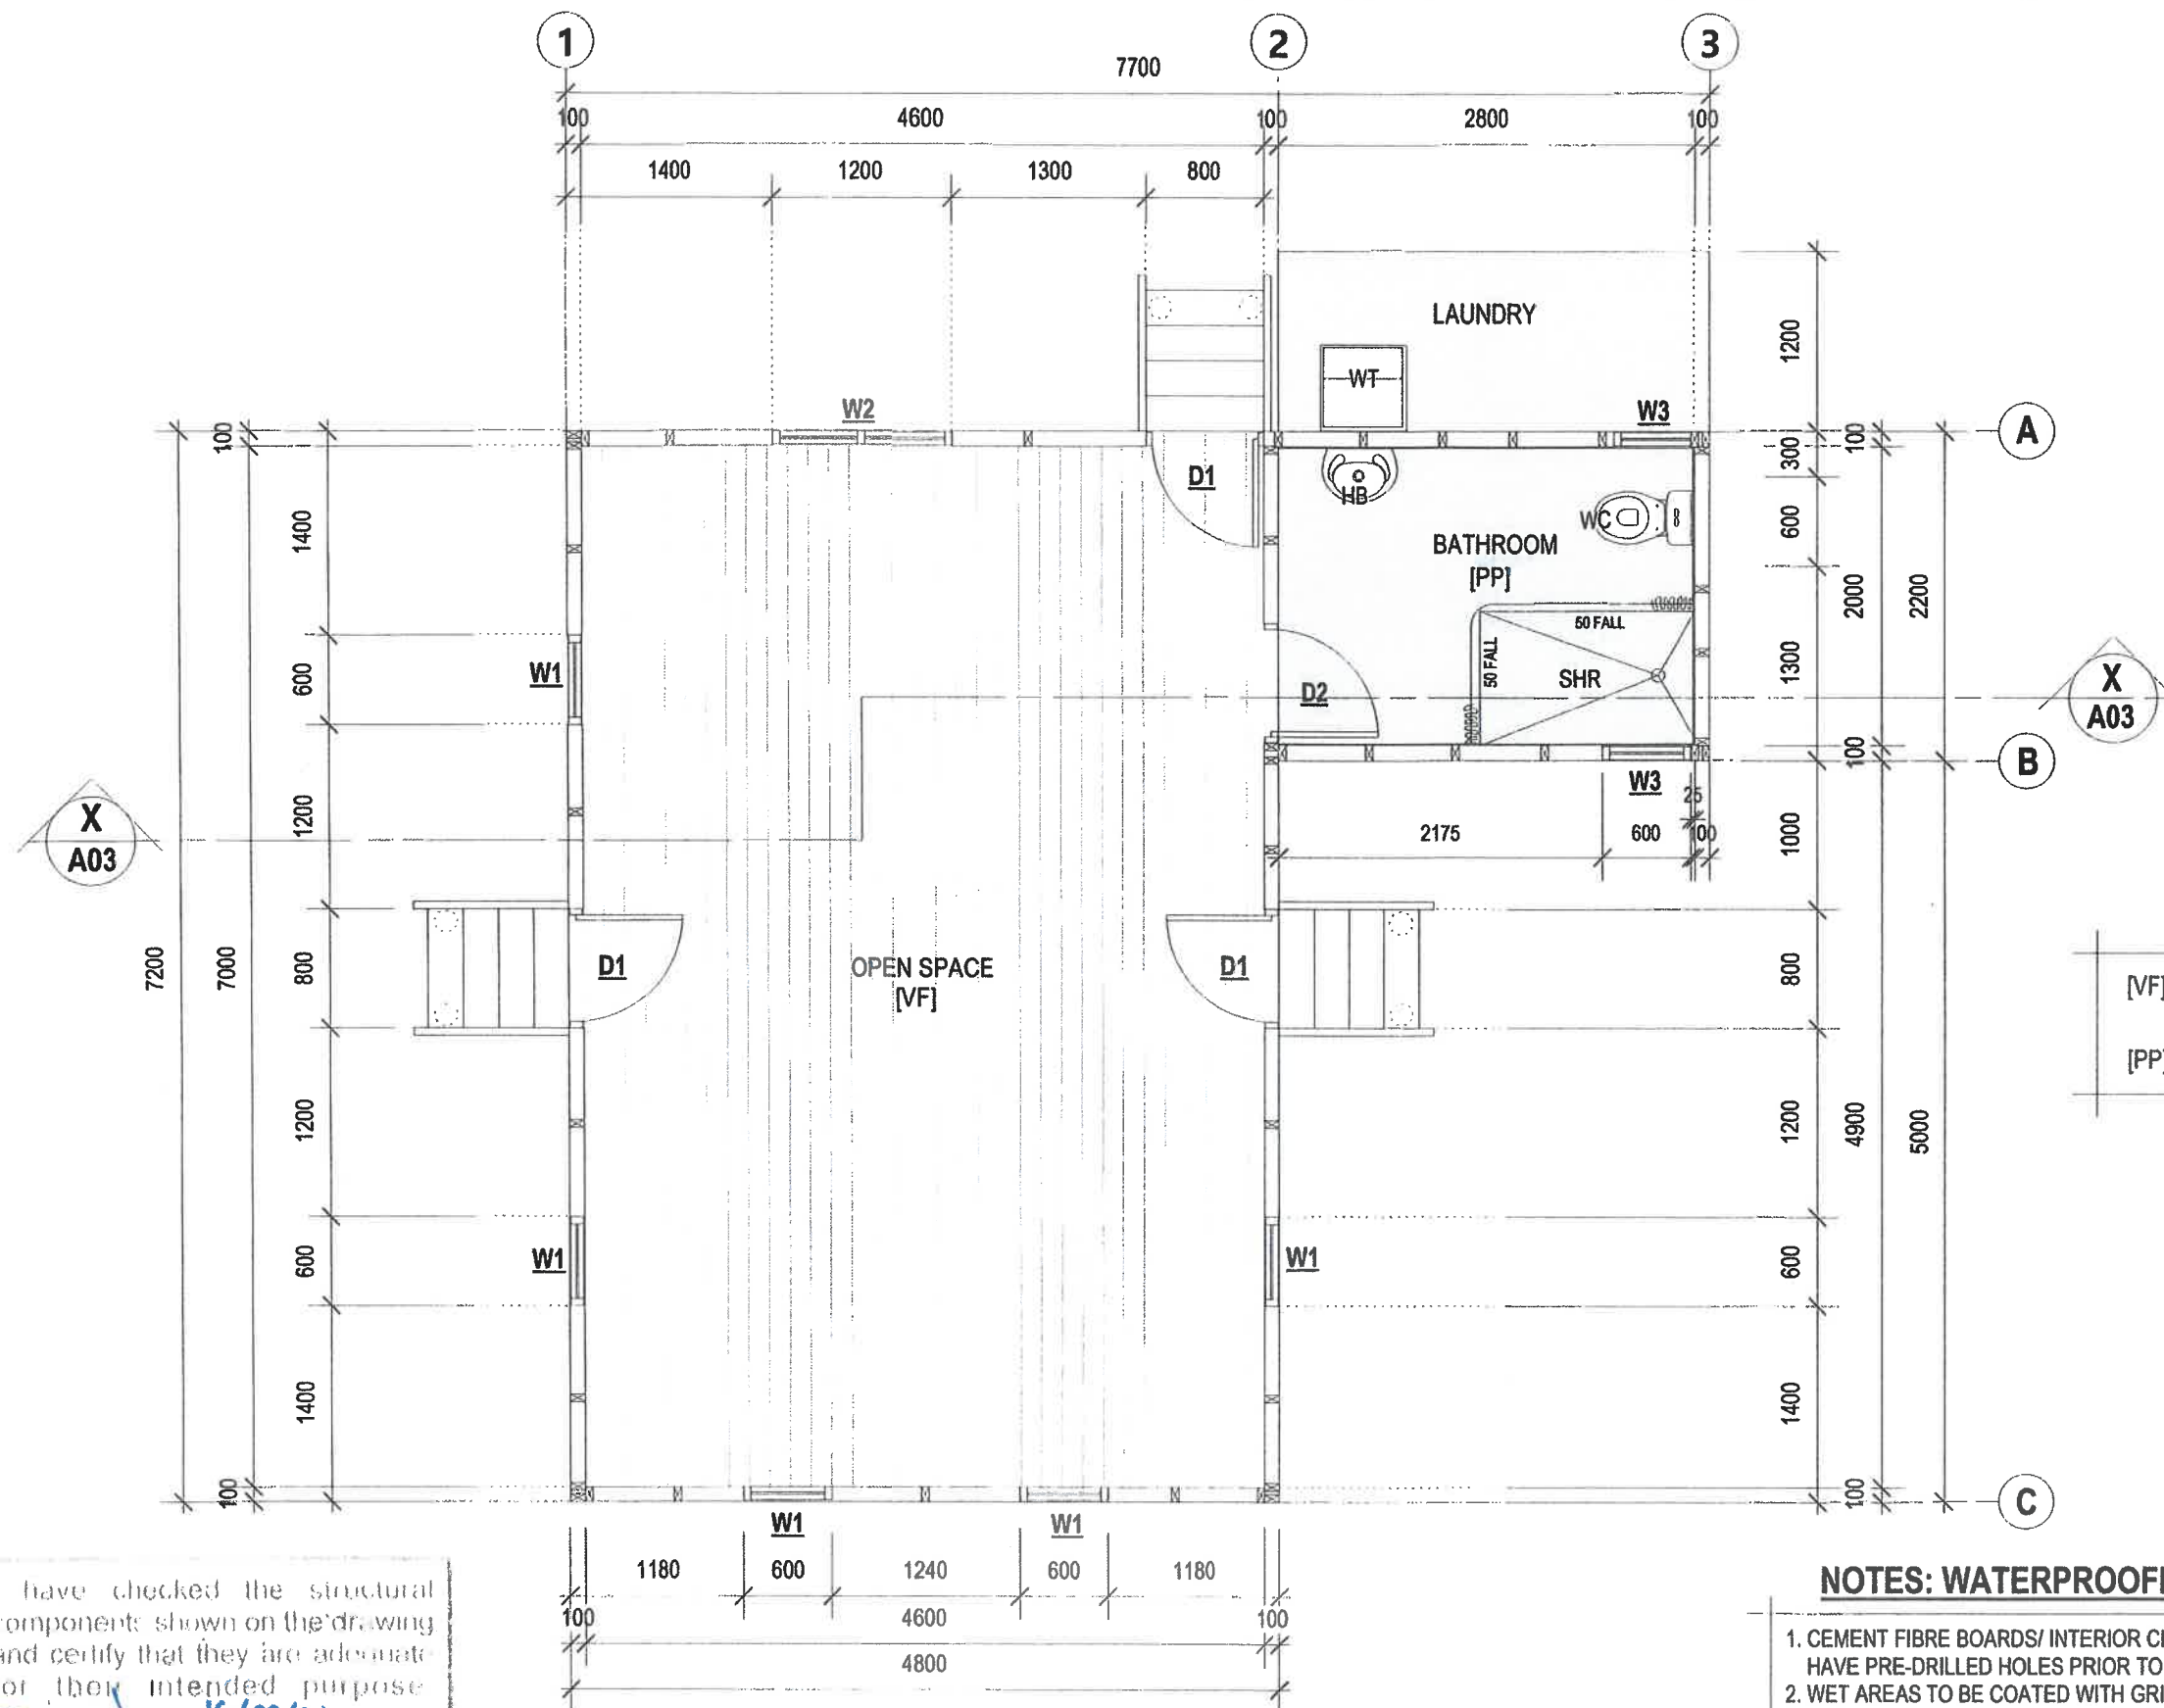

FLOOR FINISHES

- [VF] - CLEAR VANISH ON STAINED TIMBER FLOOR BOARD
[PP] - PAVING PAINT ON WET AREA FLOOR

KEY TO ELEVATION

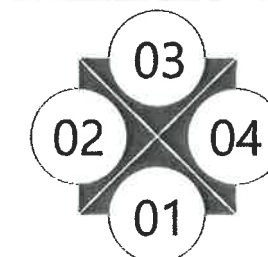

NOTES: WATERPROOFING OF WET AREAS PROCEDURES

1. CEMENT FIBRE BOARDS/ INTERIOR CLADDING SURROUNDING WET AREAS ARE REQUIRED TO HAVE PRE-DRILLED HOLES PRIOR TO FIXING.
2. WET AREAS TO BE COATED WITH GRIPSET WATERPROOFING MEMBRANE.
3. IN THE CASE OF VERTICAL JOINTS OR PERIMETER JOINTS, MESH FABRIC TO BE LAID ON TOP OF WATERPROOFING MEMBRANE.
4. WATER RESISTANT PAINT TO BE APPLIED ON MESH FABRIC.
5. SCREWS HOLES TO BE COATED/ FILLED WITH WATERPROOFING MEMBRANE AND PAINTED WITH WATER RESISTANT PAINT.

I have checked the structural components shown on the drawing and certify that they are adequate for their intended purpose.

16/02/24
Job # 24-9

ARJUNE SH CHAND (M.E. # 286)

FLOOR PLAN

scale 1:50@A3

Note:

1. The contractor/ builder shall notify the designer of any discrepancies prior to producing shop drawings and commencement of work on site.
2. All dimensions are in millimeter (mm). Figure dimensions shall take precedence over scaled dimensions and larger scale drawings shall take precedence over scaled drawings.
3. Copyright: Ministry of Rural & Maritime Development and Disaster Management. All Rights Reserved.



Project Title
Regional House
1 Knolly Street
P.O. Box 2219
Govt. Bldg
Suva.

**STANDARD 7.2m X 4.8m OPEN DESIGN TIMBER FRAMED HOUSE
WITH 2.9m X 2.2m TOILET, BATHROOM & LAUNDRY AREA.**

Ministry Of Rural & Maritime Development and Disaster Management
Rural Housing Assistance Unit

Phone: (679) 3313 400
Fax: (679) 3684 973
Suva.



Designed
RHA
Drawn
RHA


Checked
HRHA
Approved
HRHA

Date
FEB' 2024
Scale
AS SHOWN

Drawing Title
FLOOR PLAN
Drawing Reference No.
4/15/1/5-1 (REV. 1)

Sheet No.

A02

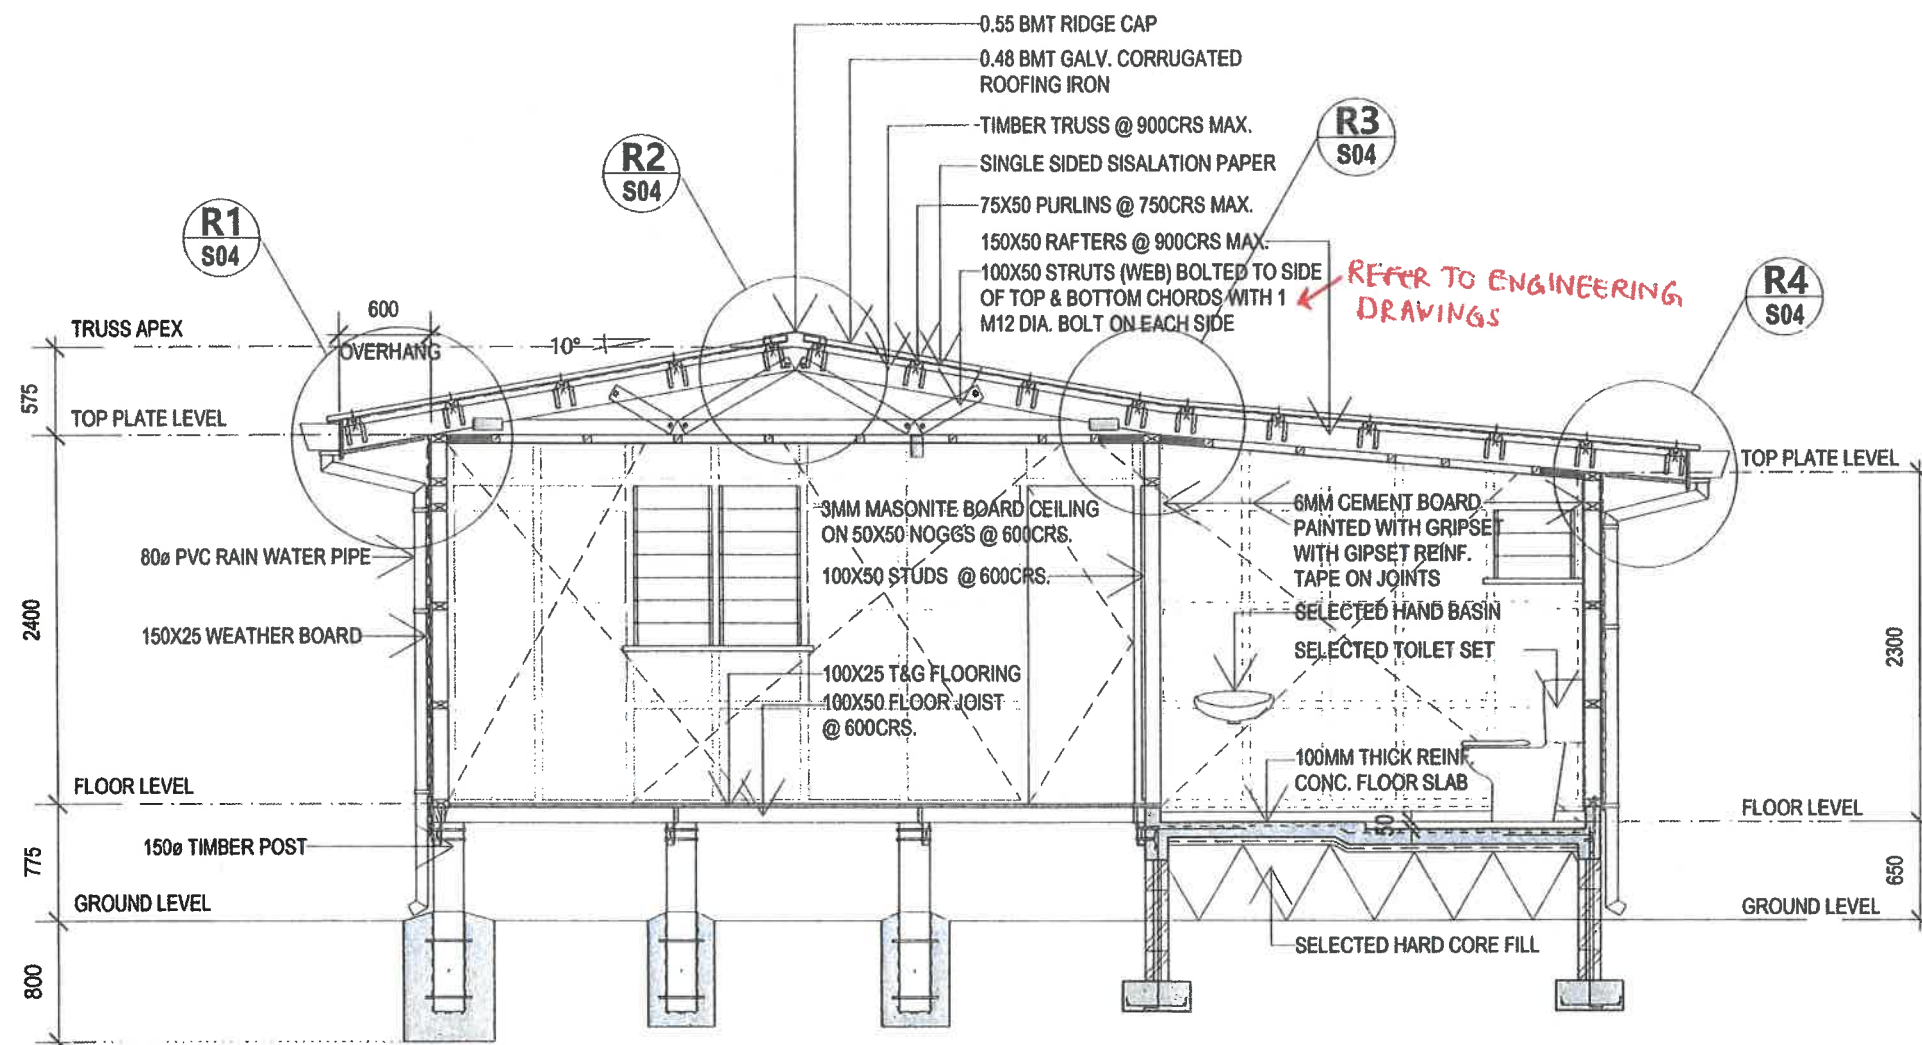

CROSS SECTION X-X
scale 1:50@A3

I have checked the structural components shown on the drawing and certify that they are adequate for their intended purpose.

16/12/24
Job # 24-9
ABHINAV CHAND (M.E. # 236)

Note:

- The contractor/ builder shall notify the designer of any discrepancies prior to producing shop drawings and commencement of work on site.
- All dimensions are in millimeter (mm). Figure dimensions shall take precedence over scaled dimensions and larger scale drawings shall take precedence over scaled drawings.
- Copyright: Ministry of Rural & Maritime Development and Disaster Management. All Rights Reserved.



Project Title
Regional House
1 Knolly Street
P.O Box 2219
Govt. Bldg
Suva

STANDARD 7.2m X 4.8m OPEN DESIGN TIMBER FRAMED HOUSE
WITH 2.9m X 2.2m TOILET, BATHROOM & LAUNDRY AREA.

Ministry Of Rural & Maritime Development and Disaster Management
Rural Housing Assistance Unit

Phone: (679) 3313 400
Fax: (679) 3684 973
Suva.



Designed

RHA

Drawn

RHA

Checked

HRHA

Approved

HRHA

Date

FEB' 2024

Scale

AS SHOWN

Drawing Title


CROSS SECTION X-X

Drawing Reference No.

4/15/1/5-1(REV. 1)


Sheet No.

A03

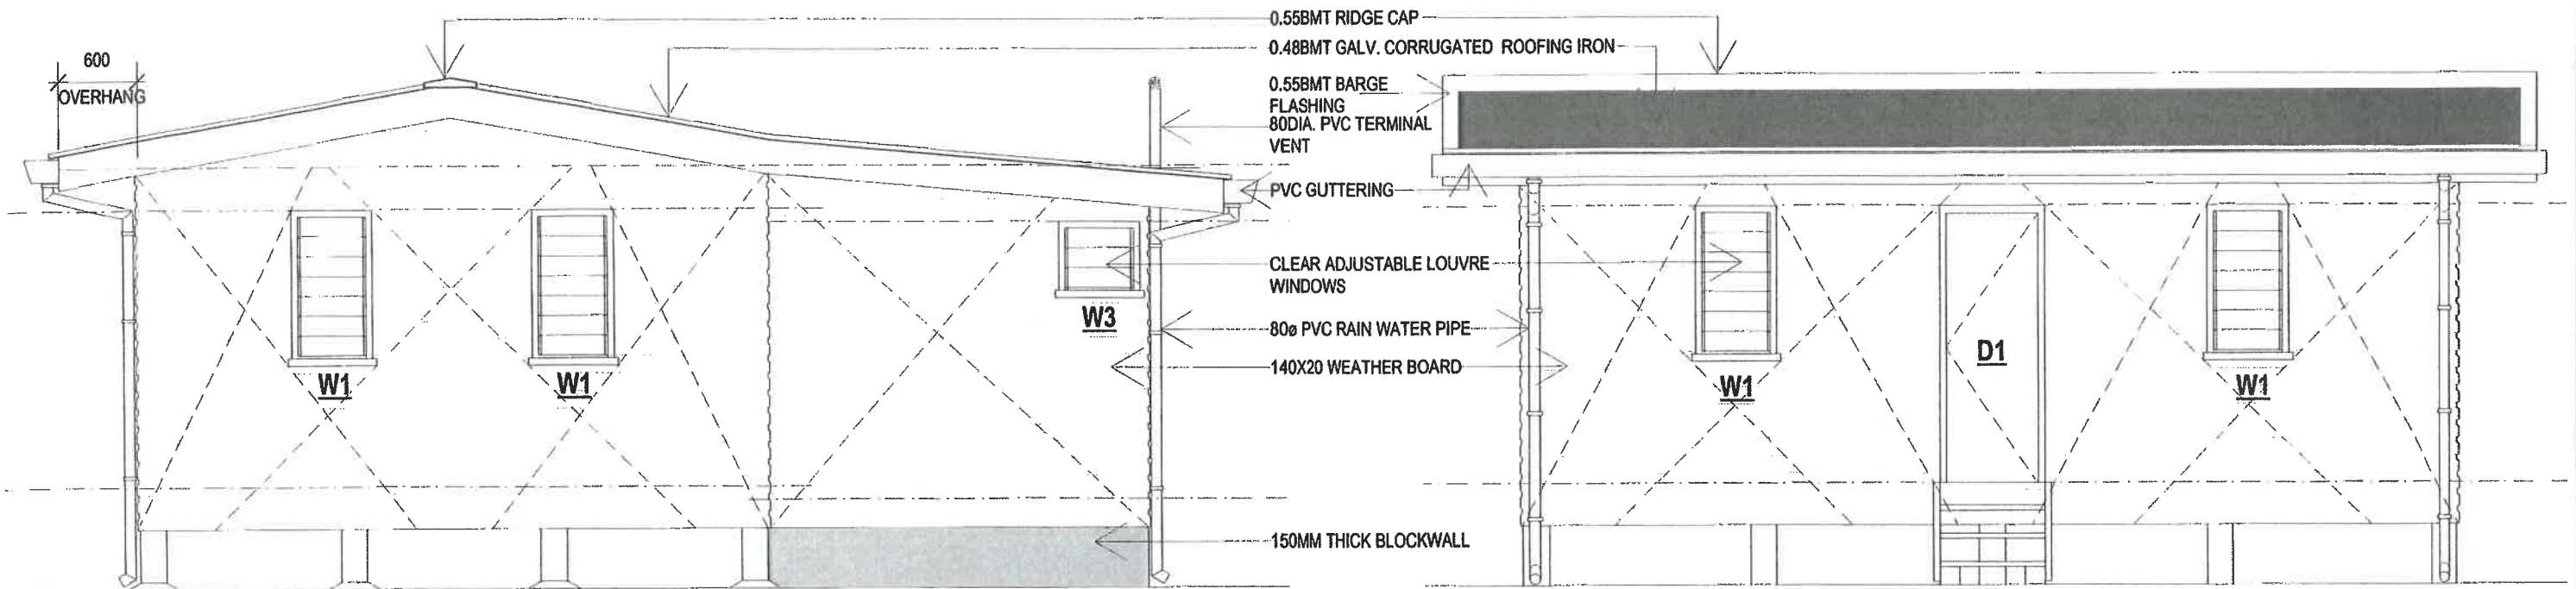

ELEVATION 01
scale 1:50@A3

ELEVATION 02
scale 1:50@A3

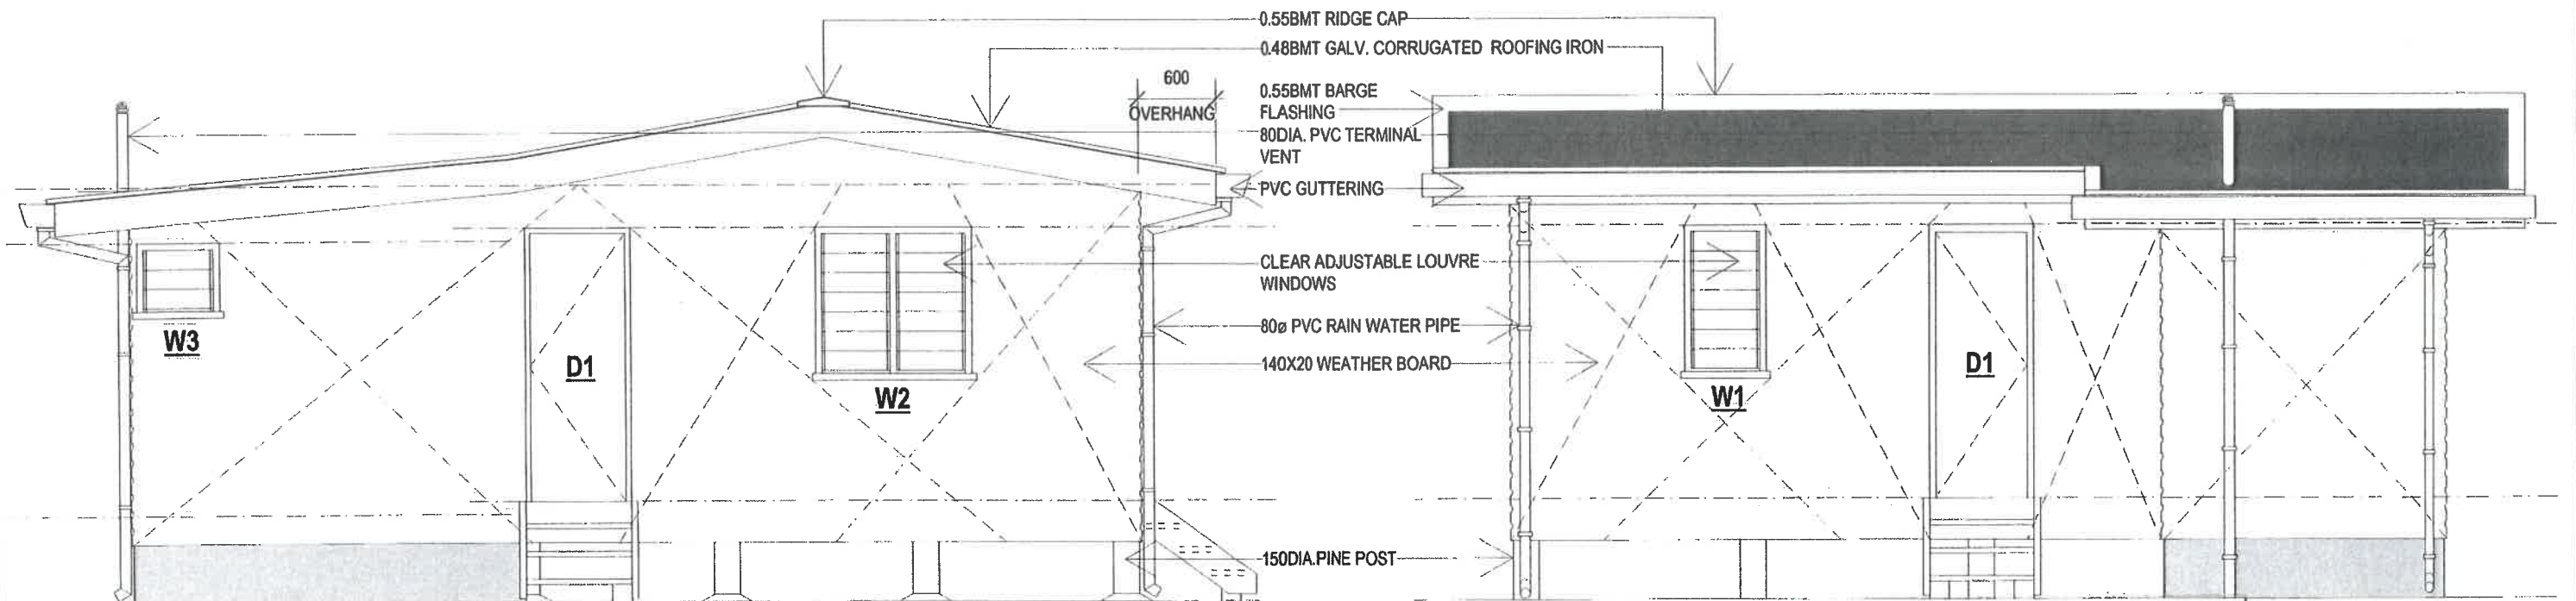

ELEVATION 03
scale 1:50@A3

ELEVATION 04
scale 1:50@A3

I have checked the structural components shown on the drawing and certify they are adequate for their intended purpose.

16/2/24
Job # 24-9
ABHINAV CHAUDHARI (M.E.) # 2305

Note:

- The contractor/ builder shall notify the designer of any discrepancies prior to producing shop drawings and commencement of work on site.
- All dimensions are in millimeter (mm). Figure dimensions shall take precedence over scaled dimensions and larger scale drawings shall take precedence over scaled drawings.
- Copyright: Ministry of Rural & Maritime Development and Disaster Management. All Rights Reserved.



Project Title
Regional House
1 Knolly Street
P.O Box 2219
Govt. Bldg
Suva.

STANDARD 7.2m X 4.8m OPEN DESIGN TIMBER FRAMED HOUSE
WITH 2.9m X 2.2m TOILET, BATHROOM & LAUNDRY AREA.

Ministry Of Rural & Maritime Development and Disaster Management
Rural Housing Assistance Unit

Phone: (679) 3313 400
Fax: (679) 3684 973
Suva.



Designed
RHA
Drawn
RHA


Checked
HRHA
Approved
HRHA

Date
FEB' 2024
Scale
AS SHOWN

Drawing Title
ELEVATIONS
Drawing Reference No.
4/15/1/5-1(REV. 1)

Sheet No.

A04

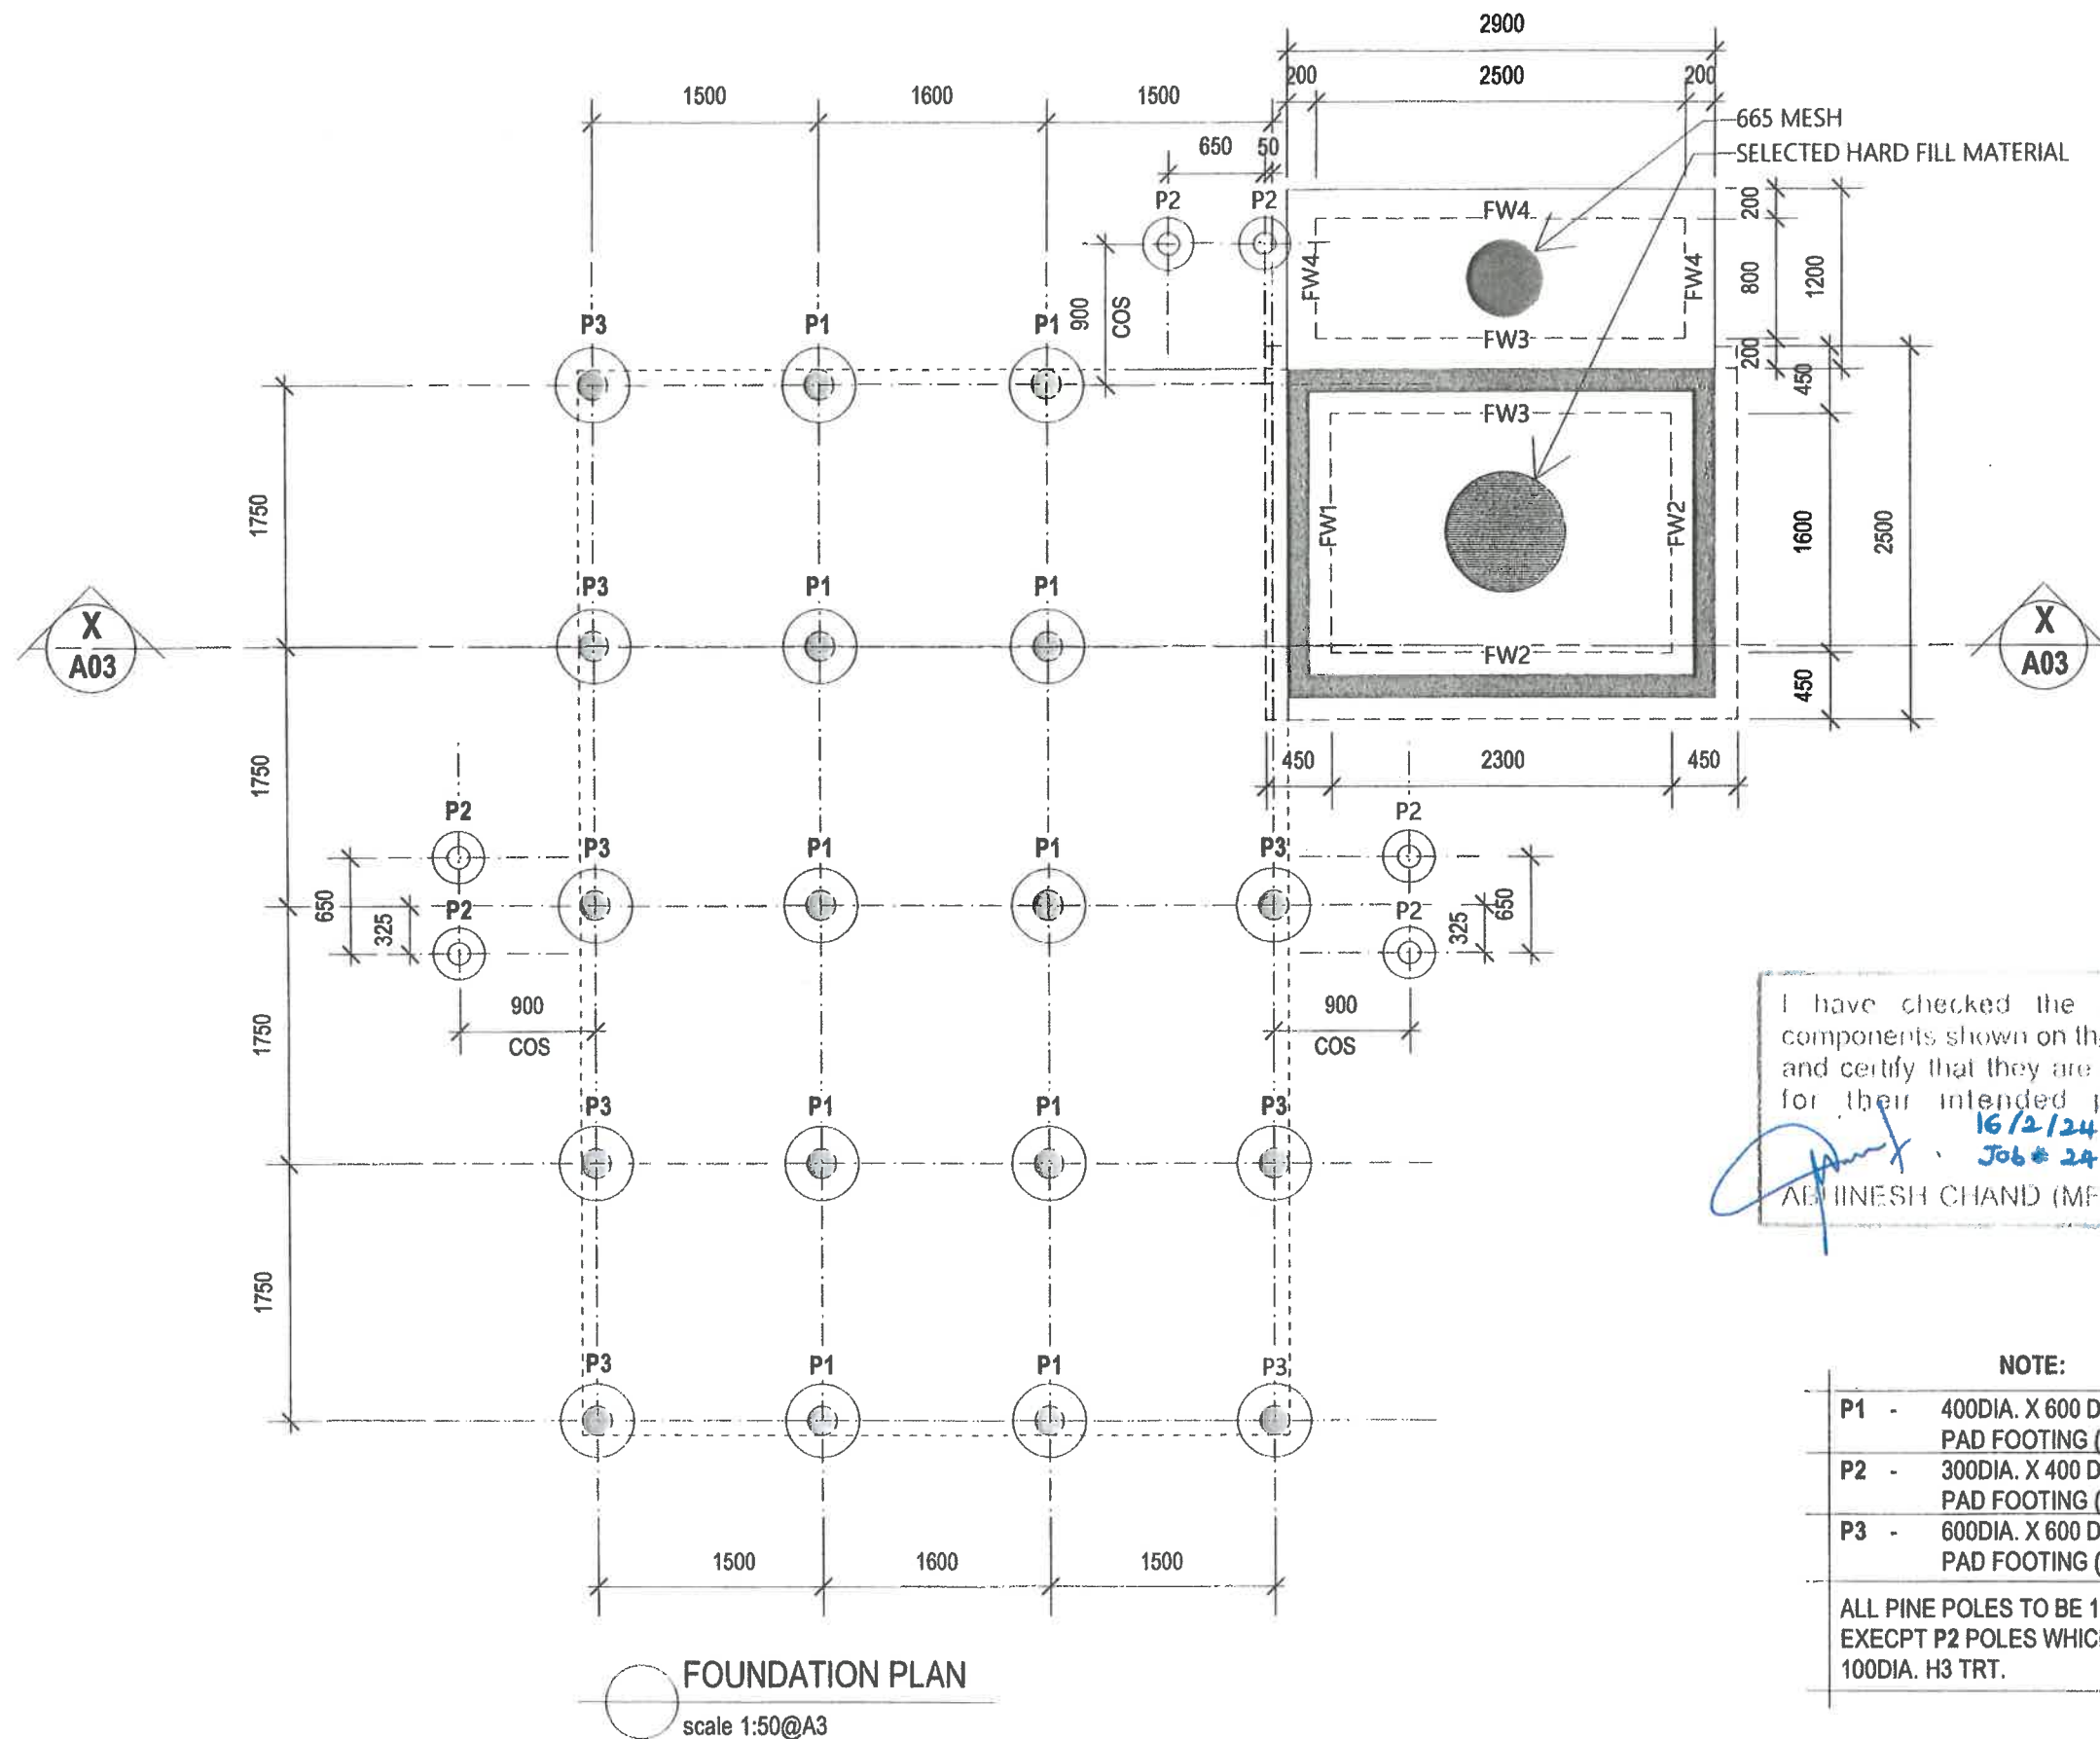

Note:

- The contractor/ builder shall notify the designer of any discrepancies prior to producing shop drawings and commencement of work on site.
- All dimensions are in millimeter (mm). Figure dimensions shall take precedence over scaled dimensions and larger scale drawings shall take precedence over scaled drawings.
- Copyright: Ministry of Rural & Maritime Development and Disaster Management. All Rights Reserved.



Project Title
STANDARD 7.2m X 4.8m OPEN DESIGN TIMBER FRAMED HOUSE WITH 2.9m X 2.2m TOILET, BATHROOM & LAUNDRY AREA.

Regional House
1 Knolly Street
P.O Box 2219
Govt. Bldg
Suva.

Ministry Of Rural & Maritime Development and Disaster Management
Rural Housing Assistance Unit

Phone: (679) 3313 400
Fax: (679) 3684 973
Suva.



Designed
RHA

Drawn
RHA

Checked
HRHA

Approved
HRHA


Date
FEB' 2024

Scale
AS SHOWN

Drawing Title
FOUNDATION PLAN

Drawing Reference No.
4/15/1/5-1 (REV. 1)

Sheet No.
A05

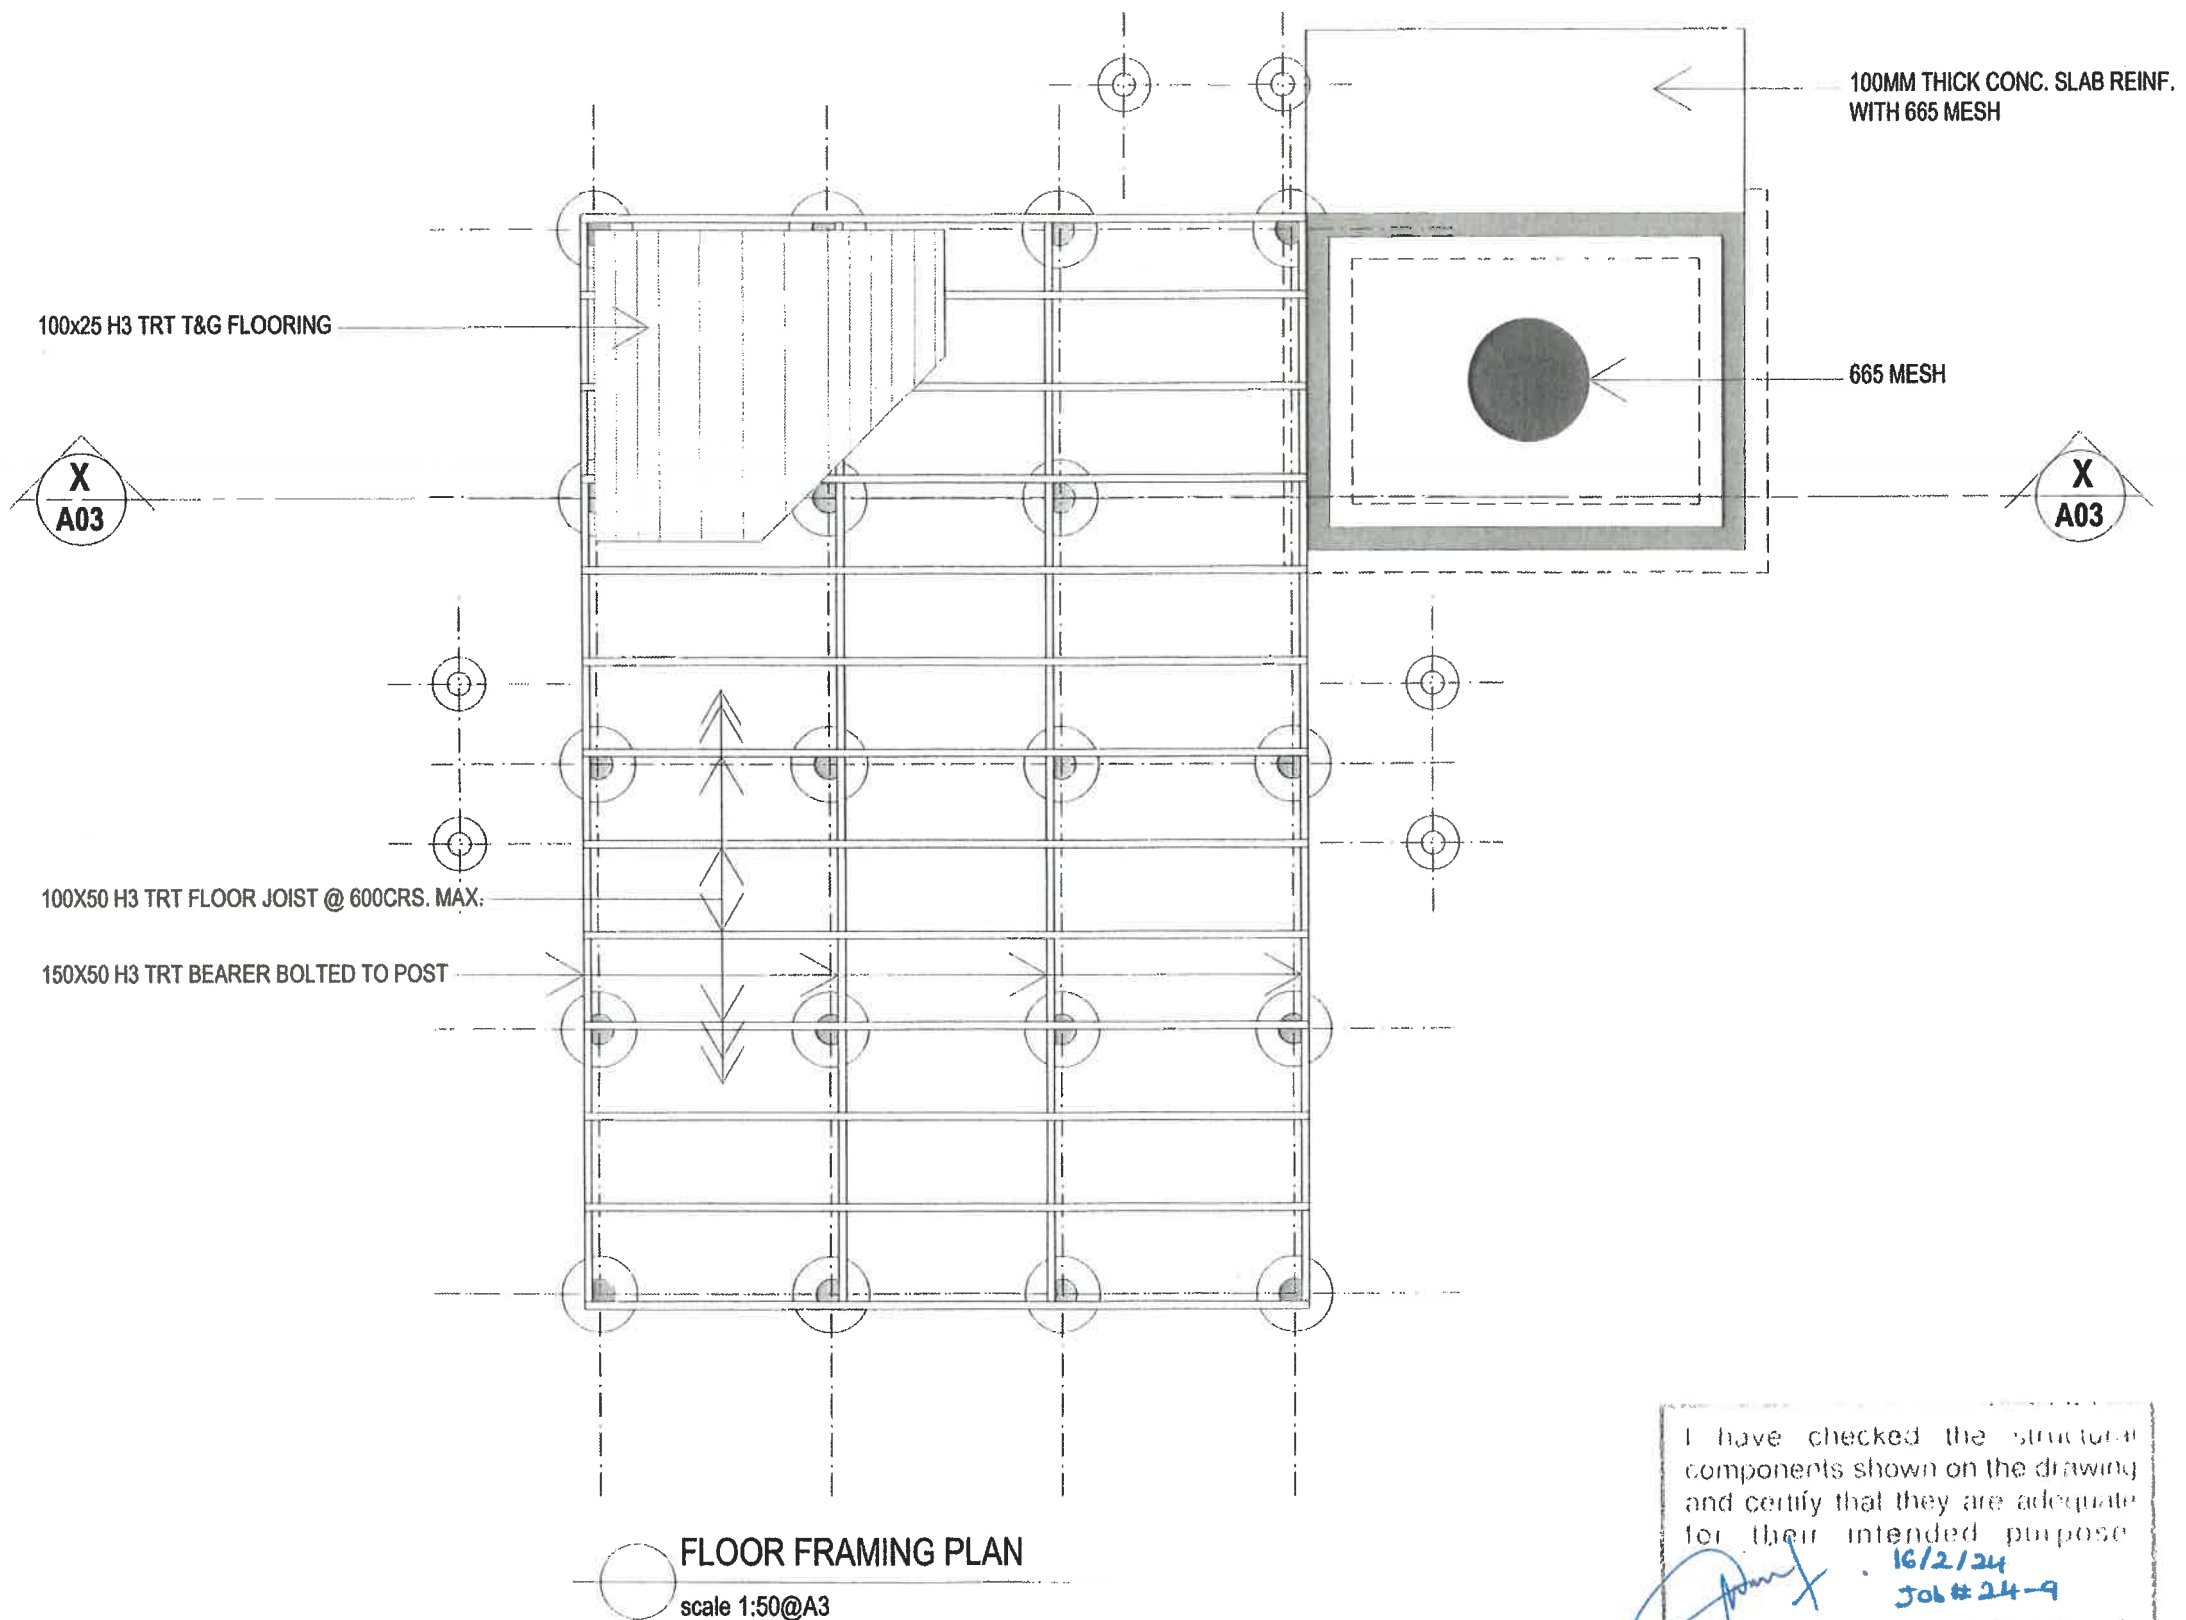

I have checked the structural components shown on the drawing and certify that they are adequate for their intended purpose.

16/2/24
Job # 24-9

ABHINAV CHAND (MEIE # 280)

Note:

1. The contractor/ builder shall notify the designer of any discrepancies prior to producing shop drawings and commencement of work on site.
2. All dimensions are in millimeter (mm). Figure dimensions shall take precedence over scaled dimensions and larger scale drawings shall take precedence over scaled drawings.
3. Copyright: Ministry of Rural & Maritime Development and Disaster Management. All Rights Reserved.



Project Title
Regional House
1 Knolly Street
P.O Box 2219
Govt. Bldg
Suva.

**STANDARD 7.2m X 4.8m OPEN DESIGN TIMBER FRAMED HOUSE
WITH 2.9m X 2.2m TOILET, BATHROOM & LAUNDRY AREA.**

Ministry Of Rural & Maritime Development and Disaster Management
Rural Housing Assistance Unit

Phone: (679) 3313 400
Fax: (679) 3684 973
Suva.



Designed

RHA

Drawn

RHA

Checked

HRHA

Approved

HRHA

Date

FEB' 2024

Scale

AS SHOWN

Drawing Title

FLOOR FRAMING PLAN

Drawing Reference No.

4/15/1/5-1 (REV. 1)

Sheet No.

A06

235X25 H3 TRT BARGE BOARD

600
OVERHANG

600
OVERHANG

25x1mm

31x1.8MM GALV. STRAPPING DIAGONAL
ROOF BRACE NAILED AT EVERY PURLIN
CROSSING WITH 32MM CLOUT NAILS

235X25 H3 TRT FASCIA BOARD

75X50 H3 TRT PURLINS SKEWED NAILED
TO RAFTER WITH 2/100MM NAILS AND
STRAPPED USING 31X1.8MM GALV.
STRAPPING NAILED WITH 4/32MM CLOUT
NAILS PER LEG

25 x 1 mm

100x50 H3 TRT DIAGONAL HORIZONTAL
TIE BOLTED TO TOP PLATE WITH
1/12DIA. BOLT ON EACH END

ROOF FRAMING PLAN
scale 1:50@A3

I have checked the structural
components shown on the drawing
and certify that they are adequate
for their intended purpose
16/2/24
Job #24-9
AIBINESH GUANO (MSE 9380)

Note:
1. The contractor/ builder shall notify the designer of any discrepancies prior to producing shop drawings and commencement of work on site.
2. All dimension's are in millimeter (mm). Figure dimensions shall take precedence over scaled dimensions and larger scale drawings shall take precedence over scaled drawings.
3. Copyright: Ministry of Rural & Maritime Development and Disaster Management. All Rights Reserved.



Project Title
**STANDARD 7.2m X 4.8m OPEN DESIGN TIMBER FRAMED HOUSE
WITH 2.9m X 2.2m TOILET, BATHROOM & LAUNDRY AREA.**
Regional House
1 Knolly Street
P.O Box 2219
Govt. Bldg
Suva.
Ministry Of Rural & Maritime Development and Disaster Management
Rural Housing Assistance Unit
Phone: (679) 3313 400
Fax: (679) 3684 973
Suva.



Designed
RHA
Drawn
RHA

Checked
HRHA
Approved
HRHA

Date
FEB' 2024
Scale
AS SHOWN

Drawing Title
ROOF FRAMING PLAN
Drawing Reference No.
4/15/1/5-1(REV. 1)

Sheet No.
A07


0.55 BMT GALV. BARGE FLASHING

0.48 BMT GALV. CORRUGATED ROOFING
SCREWED TO PURLINS WITH TYPE 17 75MM
ROOFING SCREWS WITH CYCLONIC
ASSEMBLY

0.55 BMT GALV. RIDGE CAPPING SCREWED
TO PURLINS AND POP RIVETED ON
JOINTS

PVC GUTTERING FIXED TO FASCIA
BOARD AS PER MANUFACTURERS
SPECIFICATIONS

80 DIA. RAIN WATER NOZZLE

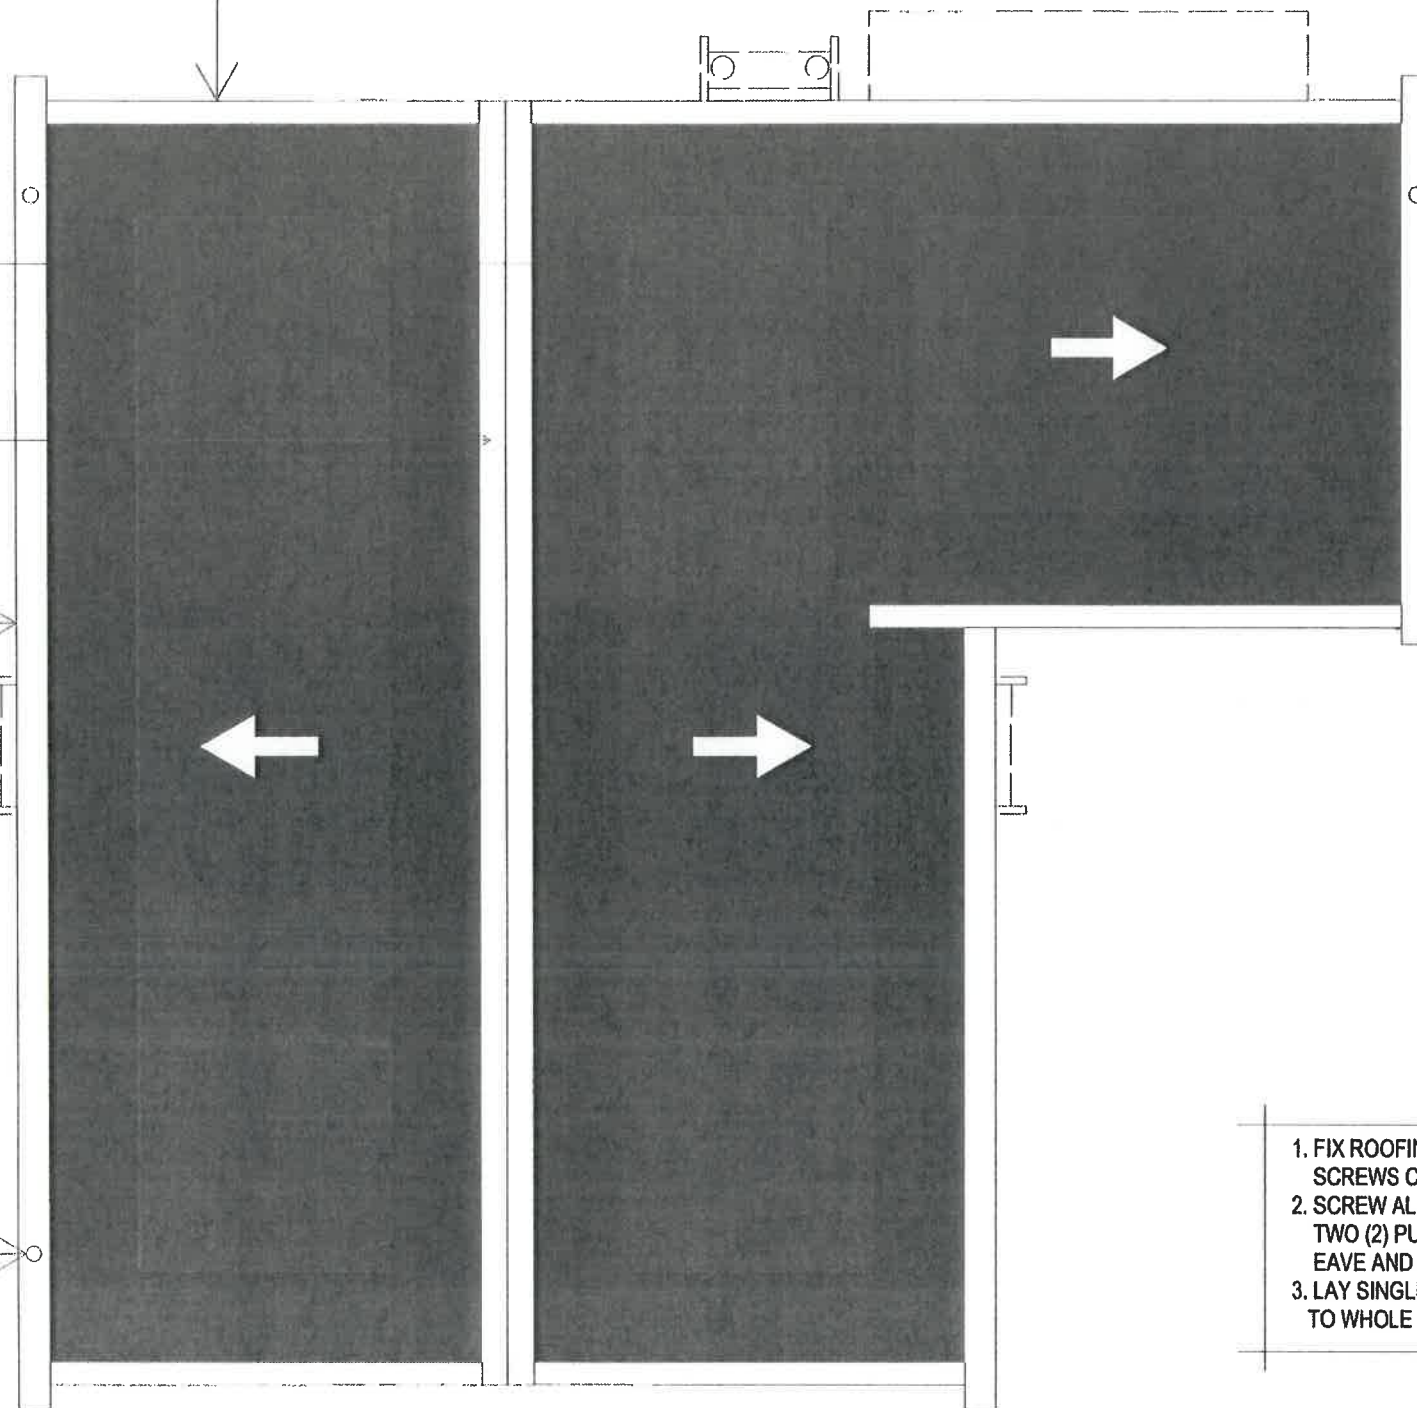

NOTE:

1. FIX ROOFING WITH TYPE17 ROOF SCREWS C/W CYCLONIC ASSEMBLY.
2. SCREW ALL CORRUGATION ON FIRST TWO (2) PURLIN LINES ON RIDGE AND EAVE AND 600MM FROM BARGE.
3. LAY SINGLE SIDED SISALATION FOIL TO WHOLE ROOF INCLUDING WET AREA

 **ROOF PLAN**
scale 1:50@A3

I have checked the structural components shown on the drawing and certify that they are adequate for their intended purpose.
- 16/2/24
Job # 24-9
AB JINESH CHAND (MFIE # 286)

Note:

1. The contractor/ builder shall notify the designer of any discrepancies prior to producing shop drawings and commencement of work on site.
2. All dimension's are in millimeter (mm). Figure dimensions shall take precedence over scaled dimensions and larger scale drawings shall take precedence over scaled drawings.
3. Copyright: Ministry of Rural & Maritime Development and Disaster Management. All Rights Reserved.




Project Title
**STANDARD 7.2m X 4.8m OPEN DESIGN TIMBER FRAMED HOUSE
WITH 2.9m X 2.2m TOILET, BATHROOM & LAUNDRY AREA.**
Regional House
1 Knolly Street
P.O Box 2219
Govt. Bldg
Suva.

Ministry Of Rural & Maritime Development and Disaster Management
Rural Housing Assistance Unit

Phone: (679) 3313 400
Fax: (679) 3684 973
Suva.





Designed RHA	Checked HRHA	Date FEB' 2024	Drawing Title ROOF PLAN
Drawn RHA	Approved HRHA	Scale AS SHOWN	Drawing Reference No. 4/15/1/5-1(REV. 1)
			Sheet No. A08

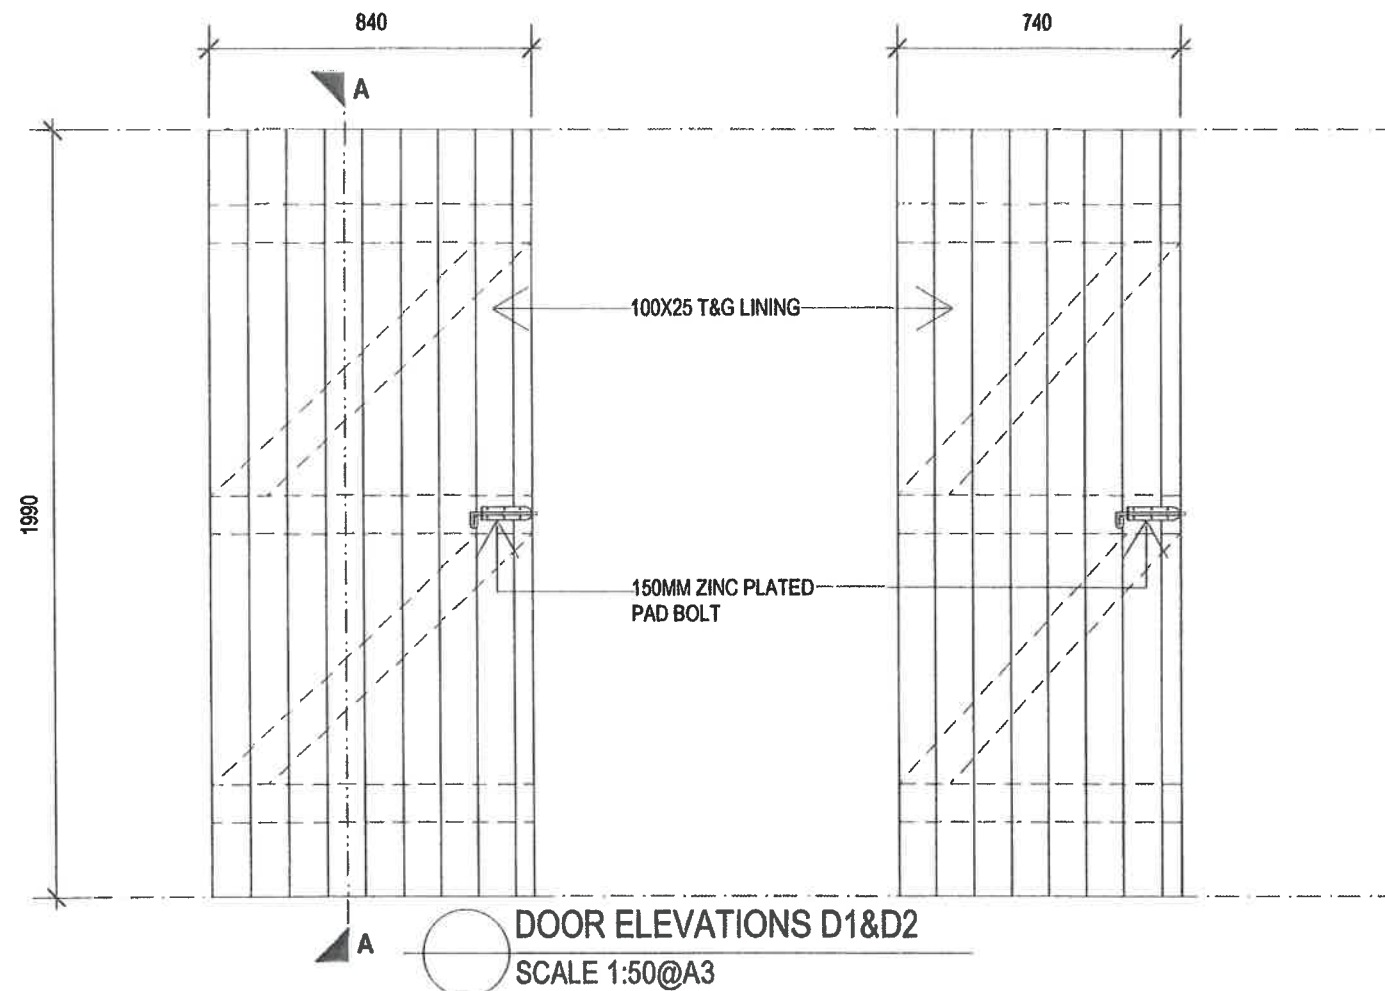

DOOR NO.	D1
QUANTITY	3 OFF
DOOR TYPE	LEDGE & BRACE DOOR
DOOR SIZE	1990MM X 840MM
HINGE TYPE	150MM ZINC PLATED TEE HINGE
LOCK TYPE	150MM ZINC PLATED PAD BOLT

DOOR NO.	D2
QUANTITY	1 OFF
DOOR TYPE	LEDGE & BRACE DOOR
DOOR SIZE	1990MM X 740MM
HINGE TYPE	150MM ZINC PLATED TEE HINGE
LOCK TYPE	150MM ZINC PLATED PAD BOLT

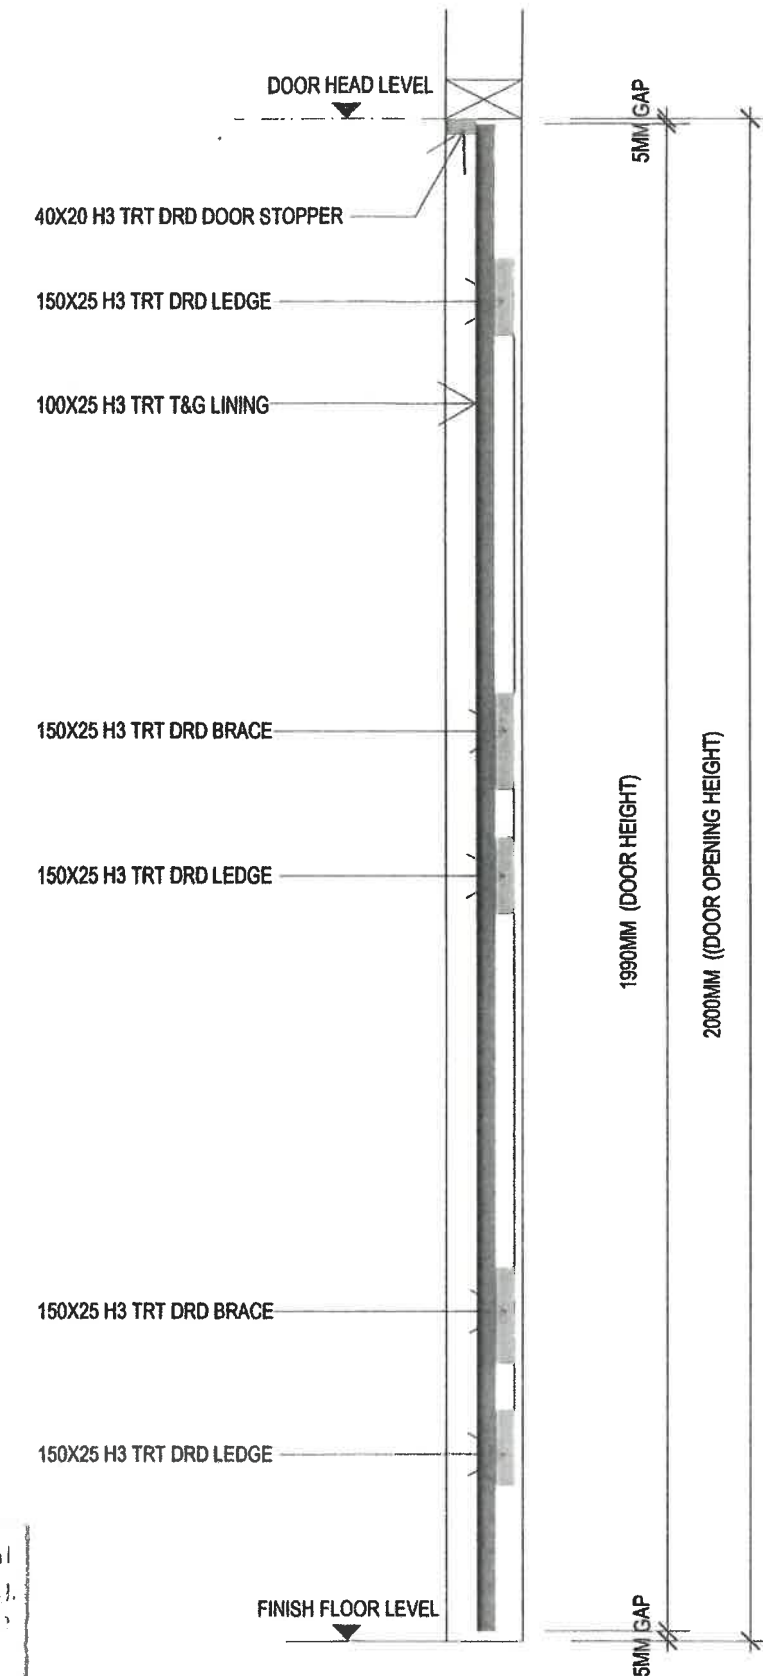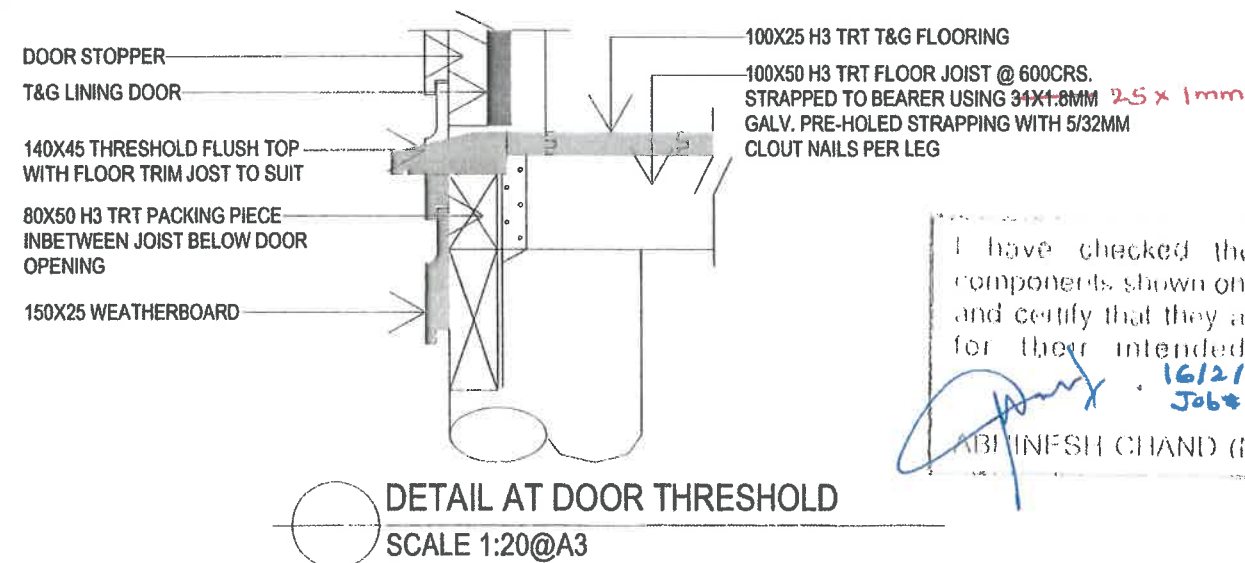

Note:

- The contractor/ builder shall notify the designer of any discrepancies prior to producing shop drawings and commencement of work on site.
- All dimensions are in millimeter (mm). Figure dimensions shall take precedence over scaled dimensions and larger scale drawings shall take precedence over scaled drawings.
- Copyright: Ministry of Rural & Maritime Development and Disaster Management. All Rights Reserved.



Project Title
STANDARD 7.2m X 4.8m OPEN DESIGN TIMBER FRAMED HOUSE
WITH 2.9m X 2.2m TOILET, BATHROOM & LAUNDRY AREA.

Regional House
1 Knolly Street
P.O Box 2219
Govt. Bldg
Suva

Ministry Of Rural & Maritime Development and Disaster Management
Rural Housing Assistance Unit

Phone: (679) 3313 400
Fax: (679) 3684 973
Suva.




Designed
RHA
Drawn
RHA

Checked
HRHA
Approved
HRHA

Date
FEB' 2024
Scale
AS SHOWN

Drawing Title
DOOR SCHEDULE
Drawing Reference No.
4/15/1/5-1(REV. 1)
Sheet No.
A09

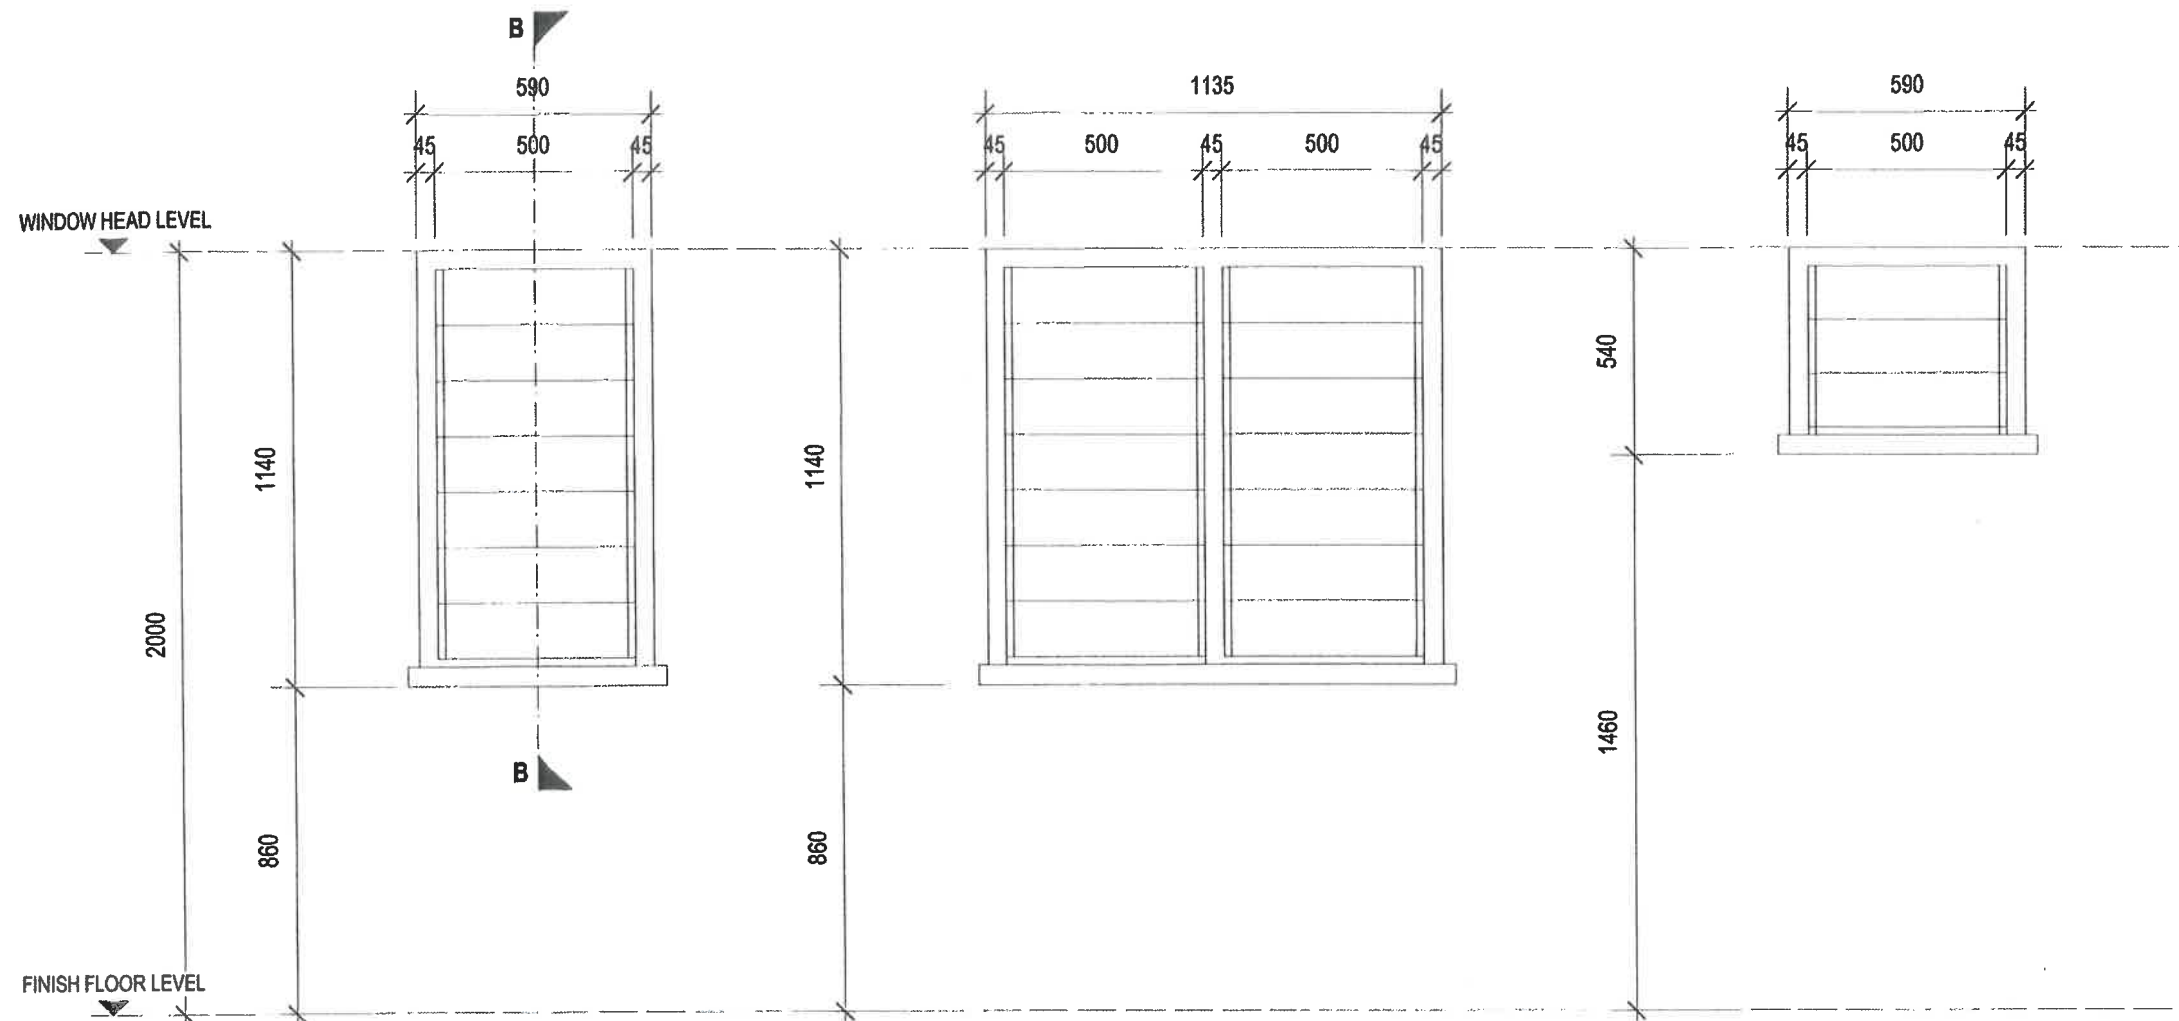


DOOR ELEVATIONS W1, W2 & W3
SCALE 1:50@A3

WINDOW NO.	W1
QUANTITY	5 OFF
WINDOW TYPE	7 BLADE GALV. LOUVRE FRAME

WINDOW NO.	W2
QUANTITY	1 OFF
WINDOW TYPE	7 BLADE GALV. LOUVRE FRAME

WINDOW NO.	W3
QUANTITY	2 OFF
WINDOW TYPE	3 BLADE GALV. LOUVRE FRAME

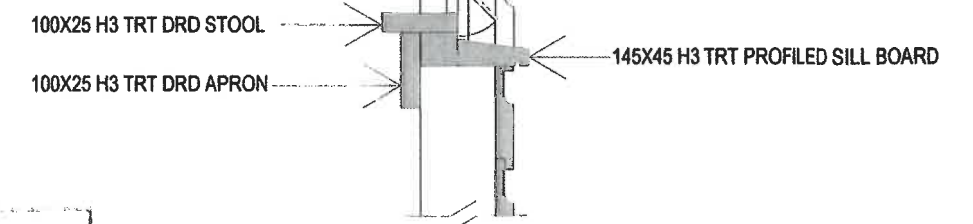

B-B WINDOW SECTION
SCALE 1:25@A3

I have checked the structural components shown on the drawing, and certify that they are adequate for their intended purpose.
16/2/24
Job # 24-9
ARI INFESH CHAND (MFE # 285)

Note:

- The contractor/builder shall notify the designer of any discrepancies prior to producing shop drawings and commencement of work on site.
- All dimensions are in millimeter (mm). Figure dimensions shall take precedence over scaled dimensions and larger scale drawings shall take precedence over scaled drawings.
- Copyright: Ministry of Rural & Maritime Development and Disaster Management. All Rights Reserved.



Project Title

**STANDARD 7.2m X 4.8m OPEN DESIGN TIMBER FRAMED HOUSE
WITH 2.9m X 2.2m TOILET, BATHROOM & LAUNDRY AREA.**

Ministry Of Rural & Maritime Development and Disaster Management
Rural Housing Assistance Unit

Regional House
1 Knolly Street
P.O Box 2219
Govt. Bldg
Suva.

Phone: (679) 3313 400
Fax: (679) 3684 973
Suva.



Designed

RHA

Drawn

RHA

Checked

HRHA

Approved

HRHA

Date

FEB' 2024

Scale

AS SHOWN

Drawing Title


WINDOW SCHEDULE

Drawing Reference No.

4/15/1/5-1(REV. 1)


Sheet No.

A10

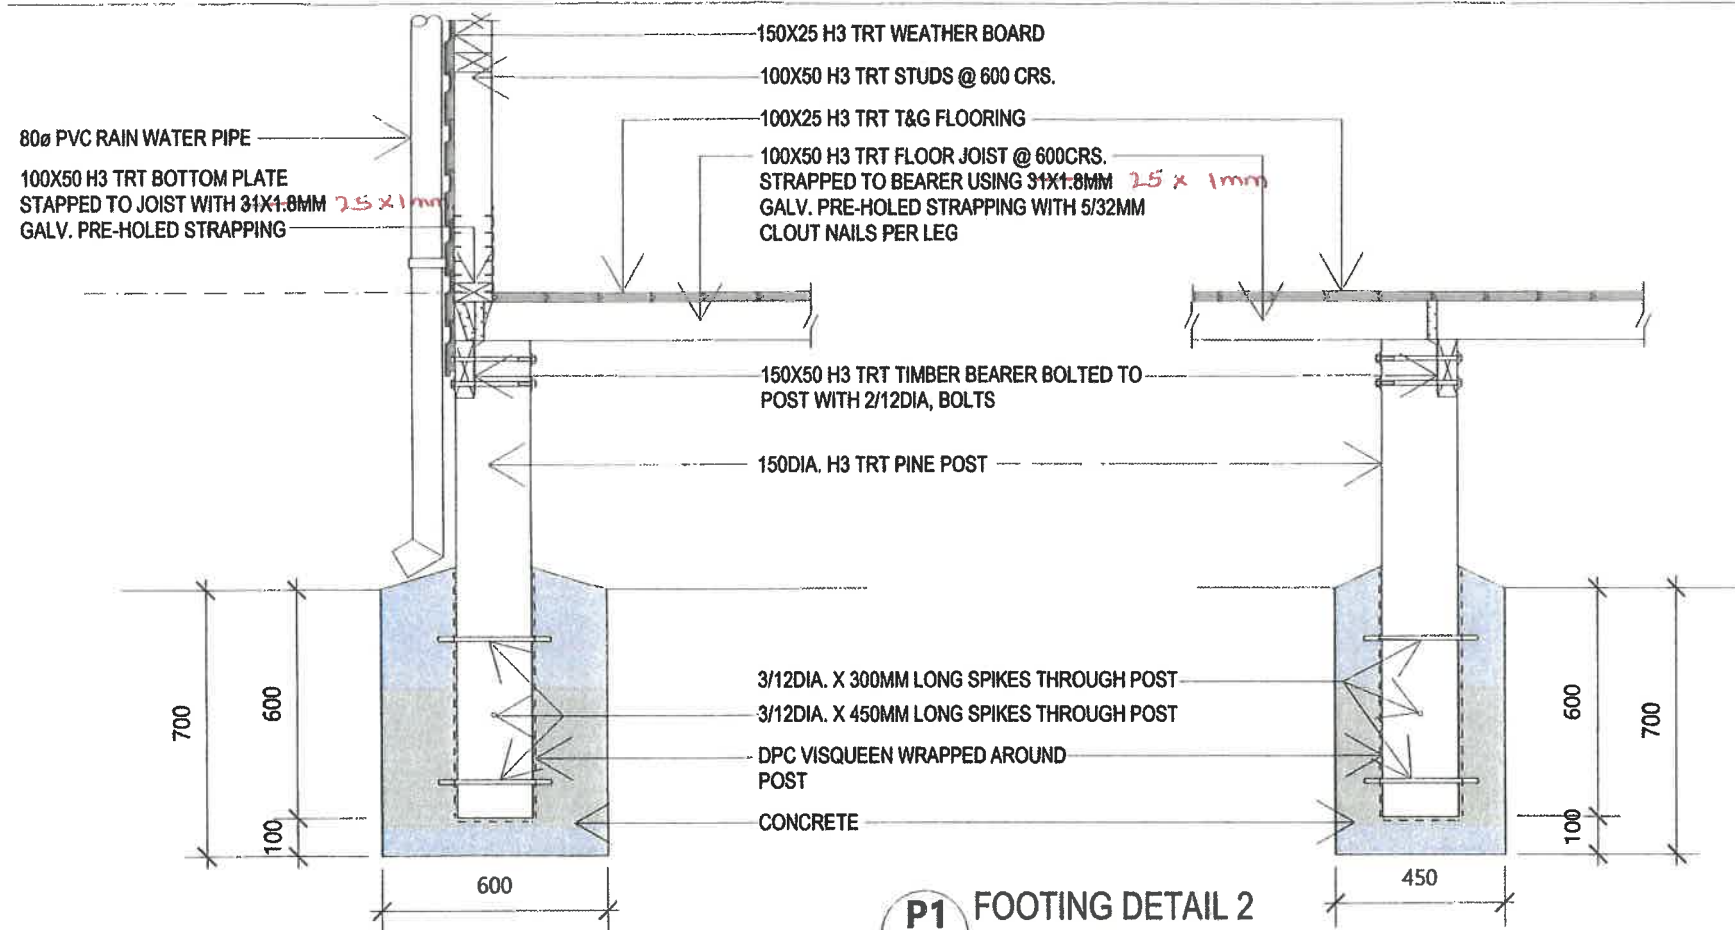


P3 FOOTING DETAIL 1
A05 scale 1:20@A3

P1 FOOTING DETAIL 2
A05 scale 1:20@A3

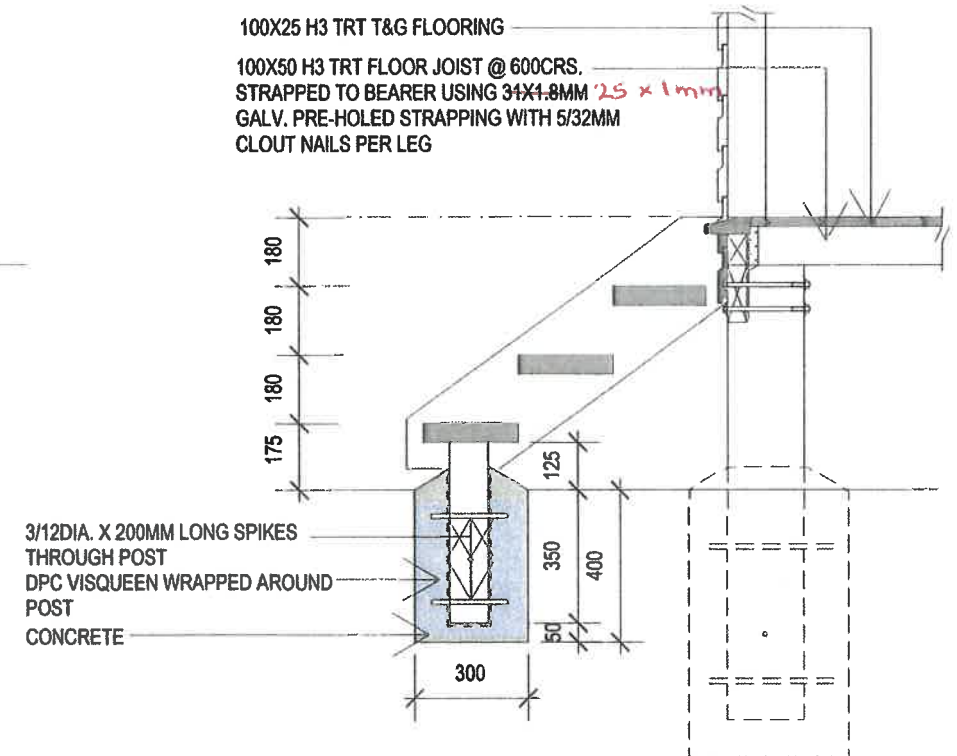

P2 FOOTING DETAIL 3
A05 scale 1:20@A3

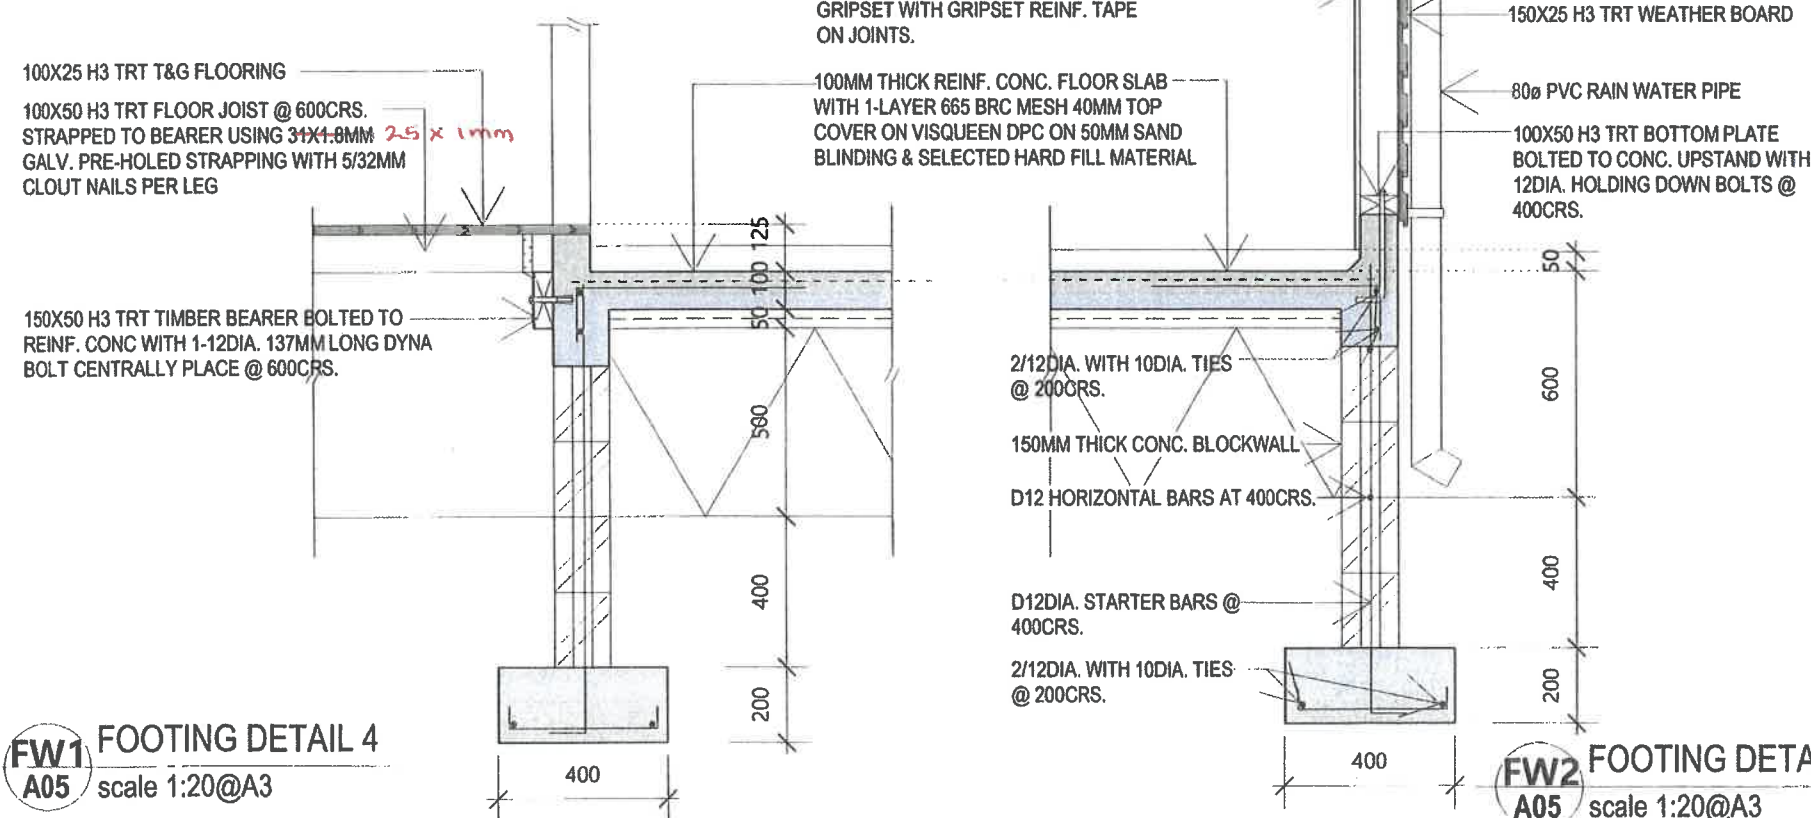

FW1 FOOTING DETAIL 4
A05 scale 1:20@A3

FW2 FOOTING DETAIL 5
A05 scale 1:20@A3

NOTE:

- ALL MAIN REINFORCEMENTS TO BE D-BARS
- ALL TIES TO BE R-BARS

I have checked the structural components shown on the drawing and certify that they are adequate for their intended purpose.

16/12/24
Job # 24-9
ABHINAV CHAND (REF # 256)

Note:
1. The contractor/ builder shall notify the designer of any discrepancies prior to producing shop drawings and commencement of work on site.
2. All dimension's are in millimeter (mm). Figure dimensions shall take precedence over scaled dimensions and larger scale drawings shall take precedence over scaled drawings.
3. Copyright: Ministry of Rural & Maritime Development and Disaster Management. All Rights Reserved.



Project Title
STANDARD 7.2m X 4.8m OPEN DESIGN TIMBER FRAMED HOUSE WITH 2.9m X 2.2m TOILET, BATHROOM & LAUNDRY AREA.
Regional House
1 Knolly Street
P.O Box 2219
Govt. Bldg
Suva.
Ministry Of Rural & Maritime Development and Disaster Management
Rural Housing Assistance Unit


Phone: (679) 3313 400
Fax: (679) 3684 973
Suva.




Designed
RHA
Checked
HRHA
Drawn
RHA
Approved
HRHA

Date
FEB' 2024
Scale
AS SHOWN

Drawing Title
FOOTING DETAILS
Drawing Reference No.
4/15/1/5-1(REV. 1)
Sheet No.
S01

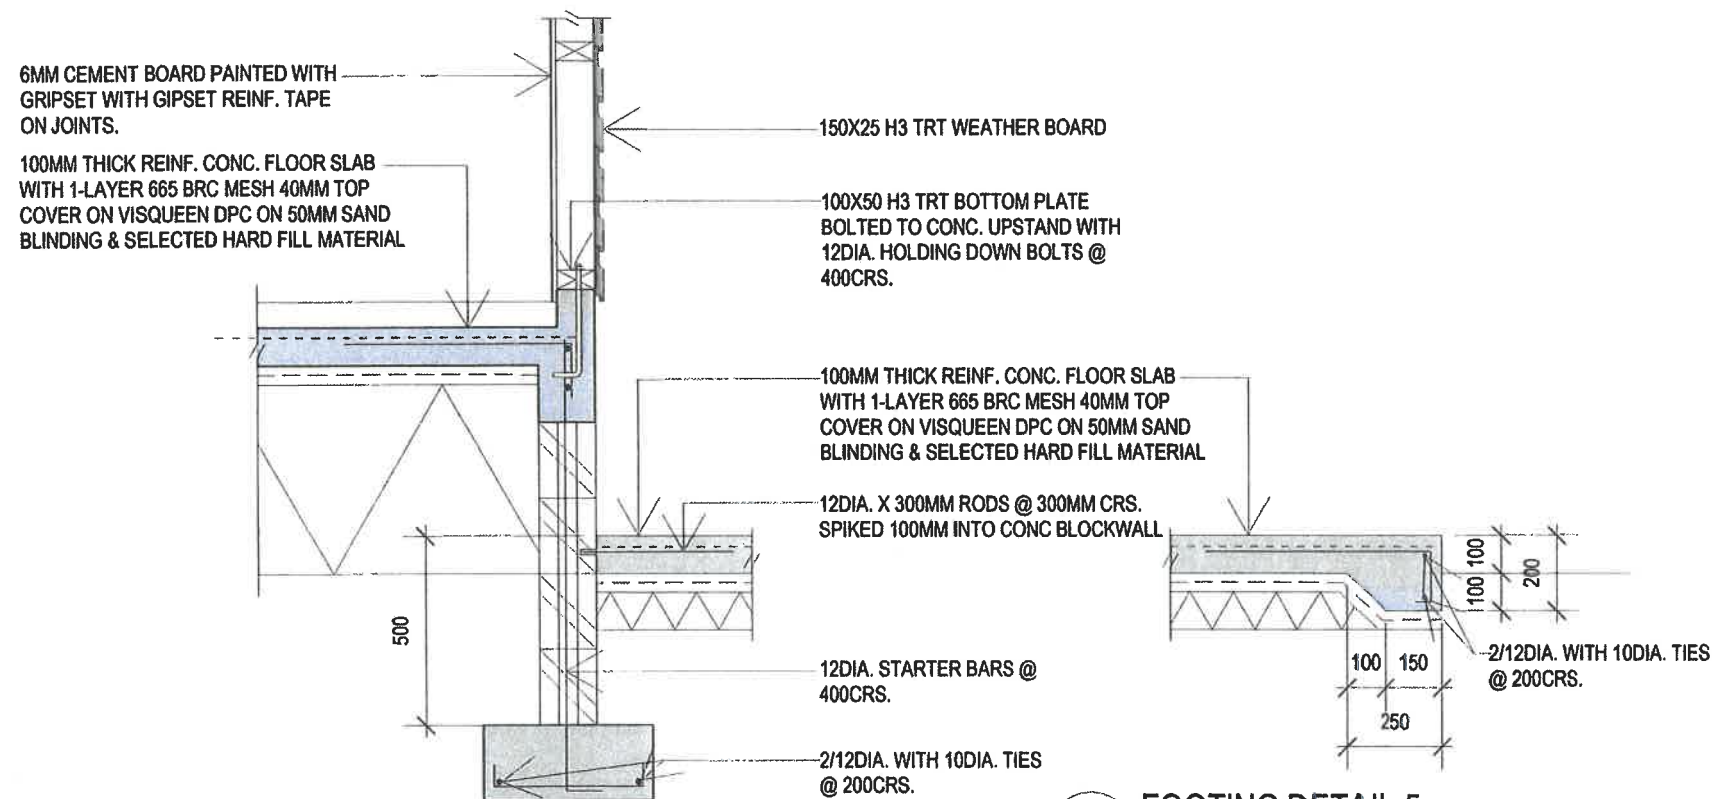

FW3 FOOTING DETAIL 5
A05 scale 1:20@A3

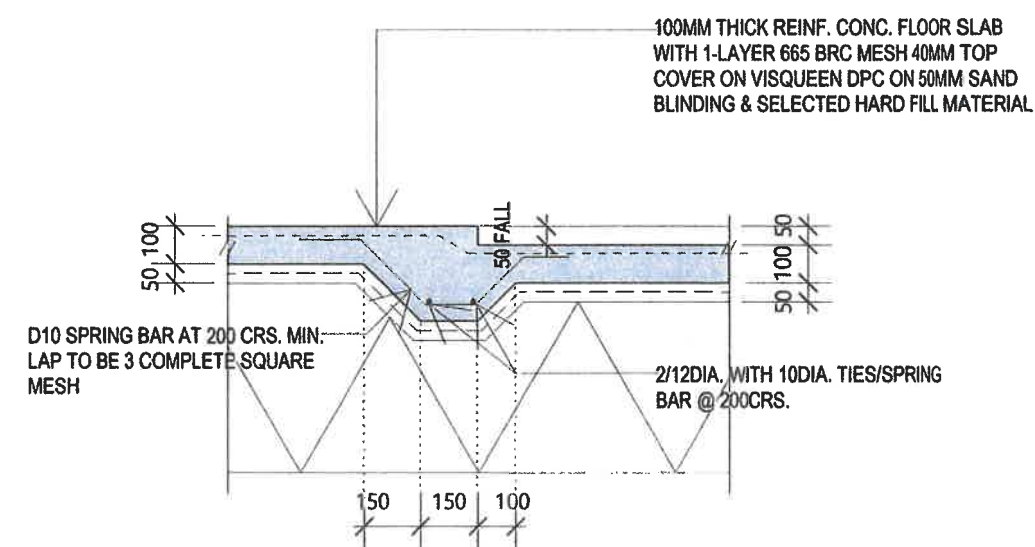

FW4 SHOWER FALL DETAIL
A05 scale 1:20@A3

I have checked the structural components shown on the drawing and certify that they are adequate for their intended purpose.

6/2/24
Job # 24-9
ABHINAV CHAND (MHE # 200)

Note:

1. The contractor/builder shall notify the designer of any discrepancies prior to producing shop drawings and commencement of work on site.
2. All dimensions are in millimeter (mm). Figure dimensions shall take precedence over scaled dimensions and larger scale drawings shall take precedence over scaled drawings.
3. Copyright: Ministry of Rural & Maritime Development and Disaster Management. All Rights Reserved.



Project Title
STANDARD 7.2m X 4.8m OPEN DESIGN TIMBER FRAMED HOUSE WITH 2.9m X 2.2m TOILET, BATHROOM & LAUNDRY AREA.

Ministry Of Rural & Maritime Development and Disaster Management
Rural Housing Assistance Unit

Phone: (679) 3313 400
Fax: (679) 3684 973
Suva.



Designed
RHA
Drawn
RHA


Checked
HRHA
Approved
HRHA

Date
FEB' 2024
Scale
AS SHOWN

Drawing Title
FOOTING DETAILS
Drawing Reference No.
4/15/1/5-1 (REV. 1)

Sheet No.

S02

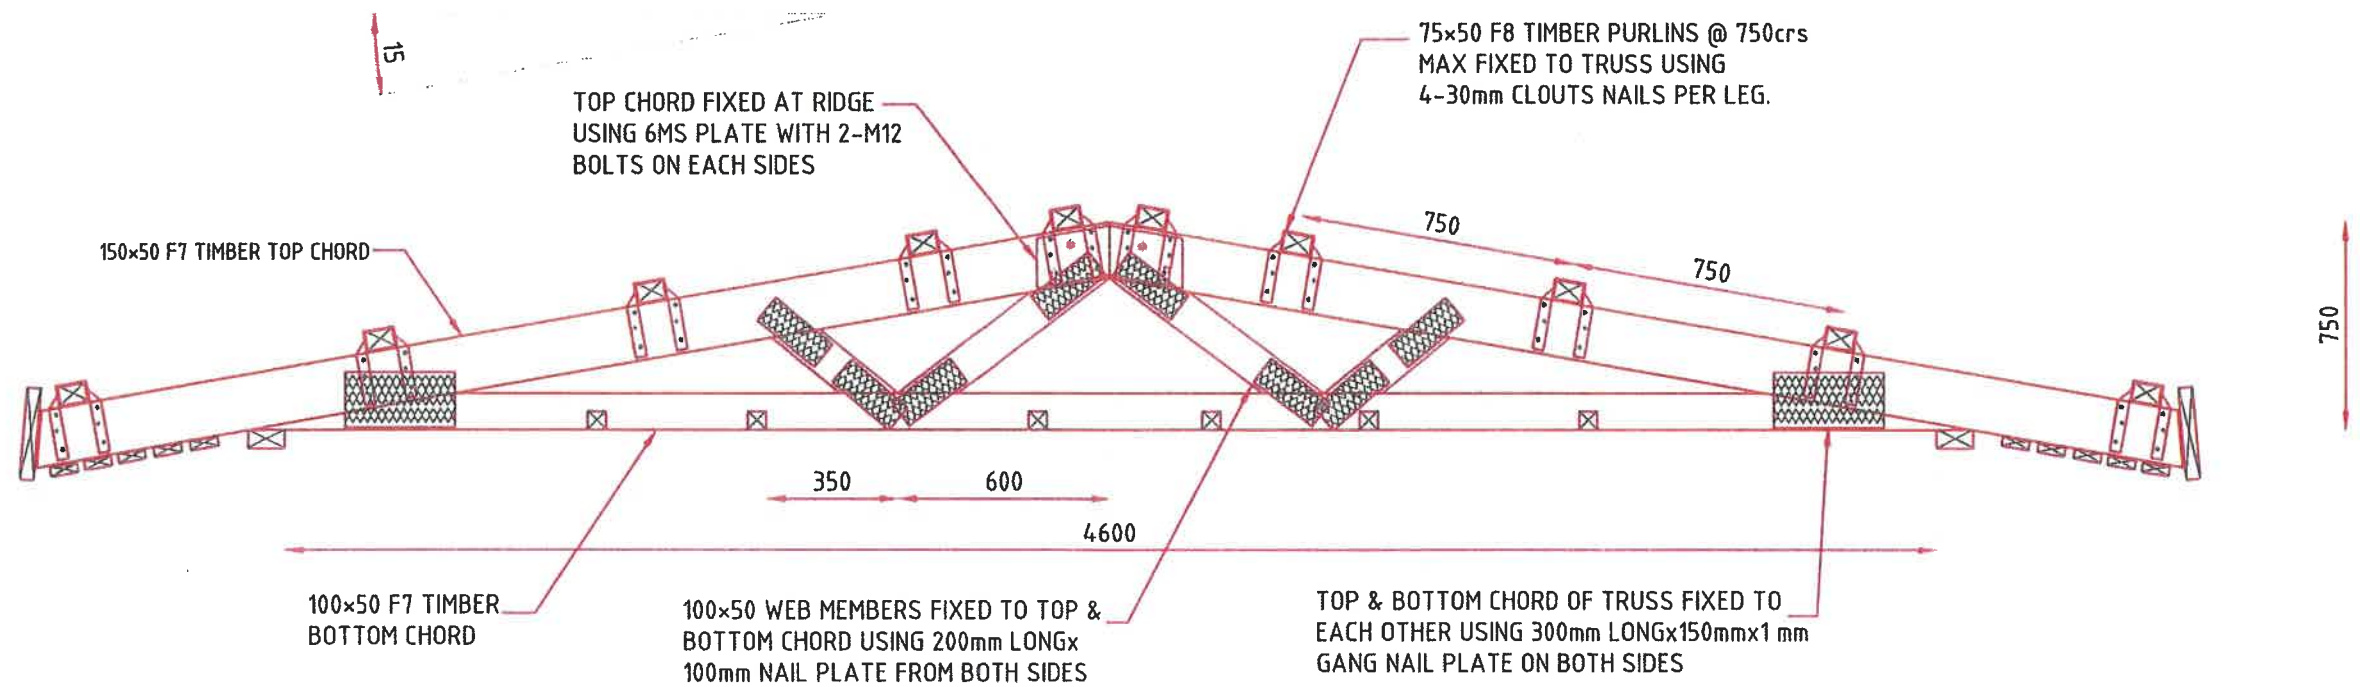

TRUSS ELEVATION

SCALE 1 : 20

I have checked the structural components shown on the drawing and certify that they are adequate for their intended purpose

16/2/24
JG-24-9
ABHINAV CHAND (MFI # 206)



CHAND ENGINEERING CONSULTANTS LTD
CONSULTING ENGINEERS & PROJECT MANAGERS
28A Vidal Avenue, Vatuwaga, Suva
P.O.Box 11708, Suva, Fiji. Ph 3380599 Fax 3380569
Email: achand@chand-engineering.com

COPYRIGHT
THE INFORMATION CONTAINED IN THIS DOCUMENT IS THE COPYRIGHT OF CHAND ENGINEERING CONSULTANTS LTD. UNLAWFUL USE OR DUPLICATION IN PART OR IN WHOLE OF THE DOCUMENT WITHOUT THE PRIOR WRITTEN CONSENT OF CHAND ENGINEERING CONSULTANTS LTD SHALL BE ACCOUNTED AS INFRINGEMENT OF COPYRIGHT


CLIENT:
MINISTRY OF RURAL AND MARITIME DEVELOPMENT AND NATIONAL DISASTER MANAGEMENT

PROJECT:
RURAL HOUSING UNIT



DRAWING TITLE:
TRUSS ELEVATION

REV	BY	DATE

DESIGNED A.A.C	DESIGN CHK	SCALE 1:50
DRAFTED RRP	DRAFTING CHK	ISSUE DATE 16/02/2024
PROJECT NO. 2024-09	DRAWING SHT S-03	REVISION

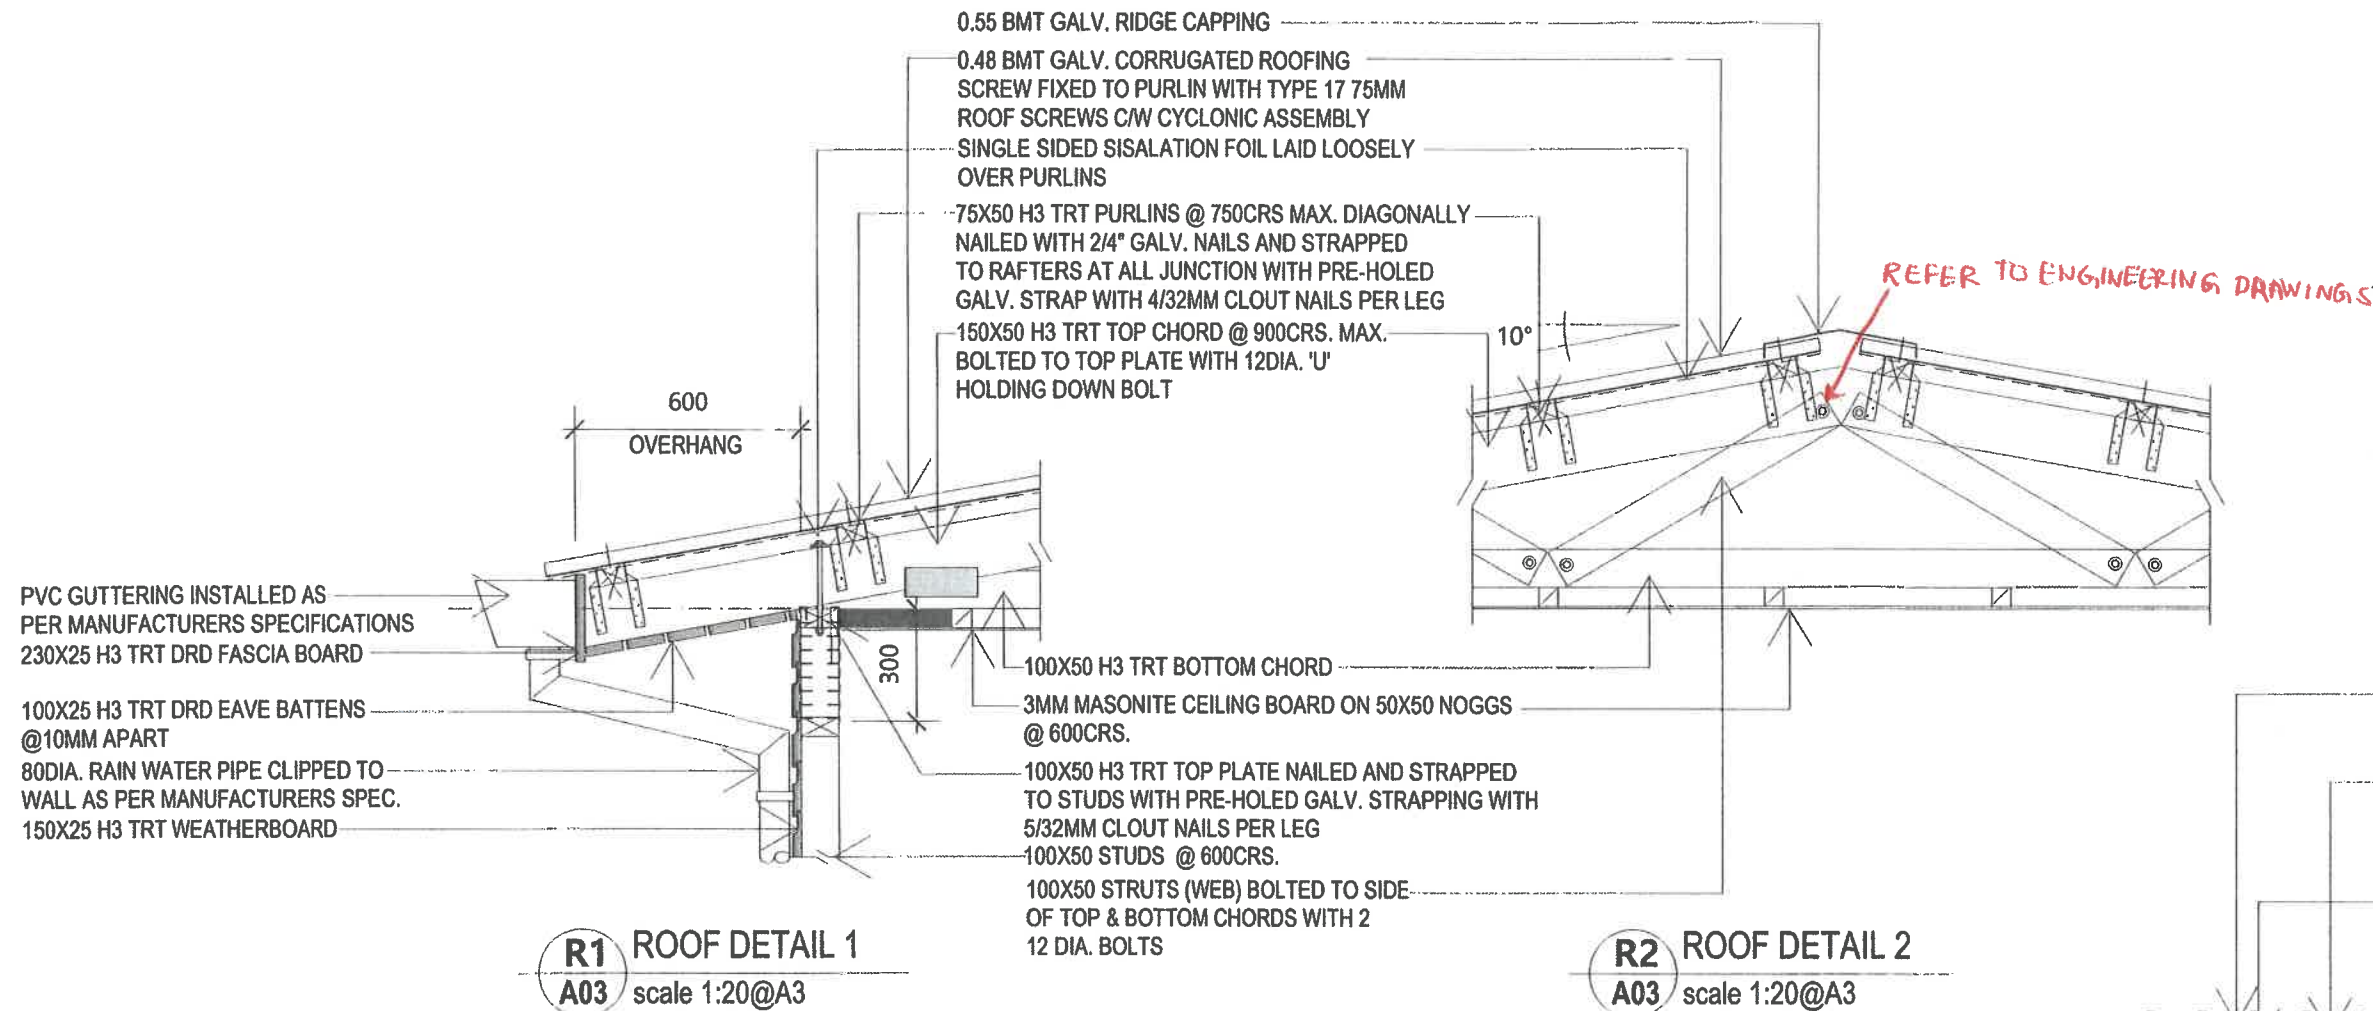

- NOTE:**
- RIDGE CAP TO BE 0.55 BMT
 - CORRUGATED ROOFING TO BE 0.48 BMT
- NOTE:**
- PURLIN TO BE FIXED TO RAFTER USING STRAPPING WITH MIN. 3 CLOUT NAILS PER LEG.
 - TOP PLATE TO BE FIXED TO STUDS USING STRAPPING WITH MIN. 5 CLOUT NAILS PER LEG.

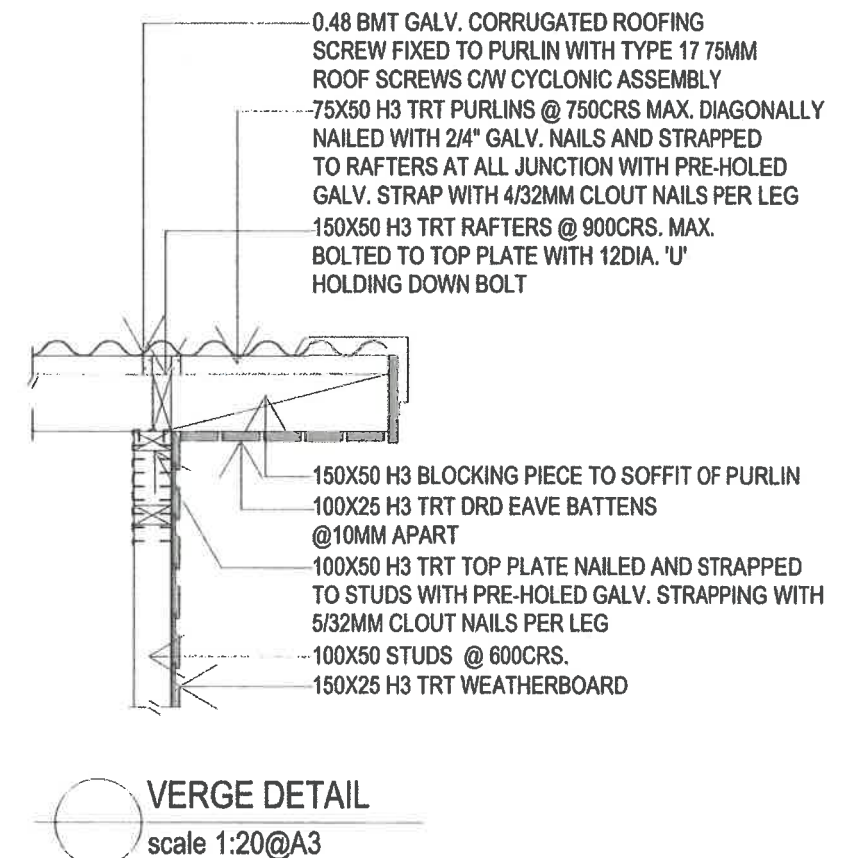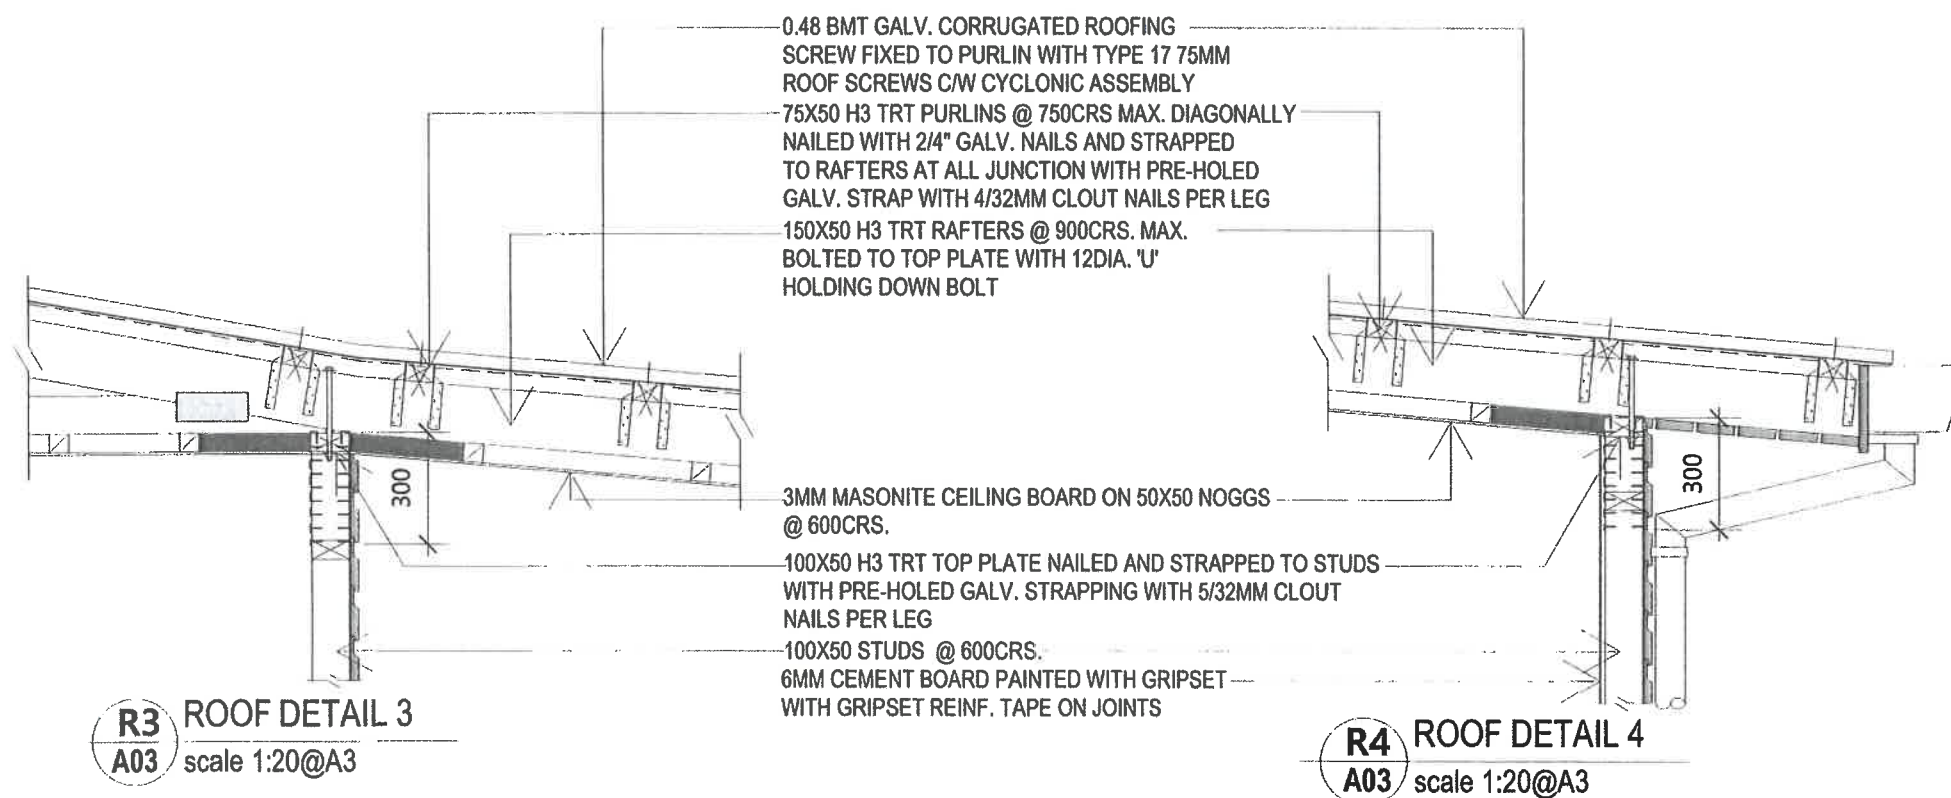

I have checked the structural components shown on the drawing and certify that they are adequate for their intended purpose.

16/2/24
Job #24-9
ABHINAV CHAND (MFE # 206)

- Note:**
- The contractor/builder shall notify the designer of any discrepancies prior to producing shop drawings and commencement of work on site.
 - All dimensions are in millimeter (mm). Figure dimensions shall take precedence over scaled dimensions and larger scale drawings shall take precedence over scaled drawings.
 - Copyright: Ministry of Rural & Maritime Development and Disaster Management. All Rights Reserved.



Project Title
STANDARD 7.2m X 4.8m OPEN DESIGN TIMBER FRAMED HOUSE WITH 2.9m X 2.2m TOILET, BATHROOM & LAUNDRY AREA.

Regional House
 1 Knolly Street
 P.O Box 2219
 Govt. Bldg
 Suva.

Ministry Of Rural & Maritime Development and Disaster Management
Rural Housing Assistance Unit

Phone: (679) 3313 400
 Fax: (679) 3684 973
 Suva.



Designed
 RHA

Drawn
 RHA

Checked
 HRHA

Approved
 HRHA


Date
 FEB' 2024

Scale
 AS SHOWN

Drawing Title
ROOF DETAILS

Drawing Reference No.
 4/15/1/5-1 (REV. 1)

Sheet No.
S04

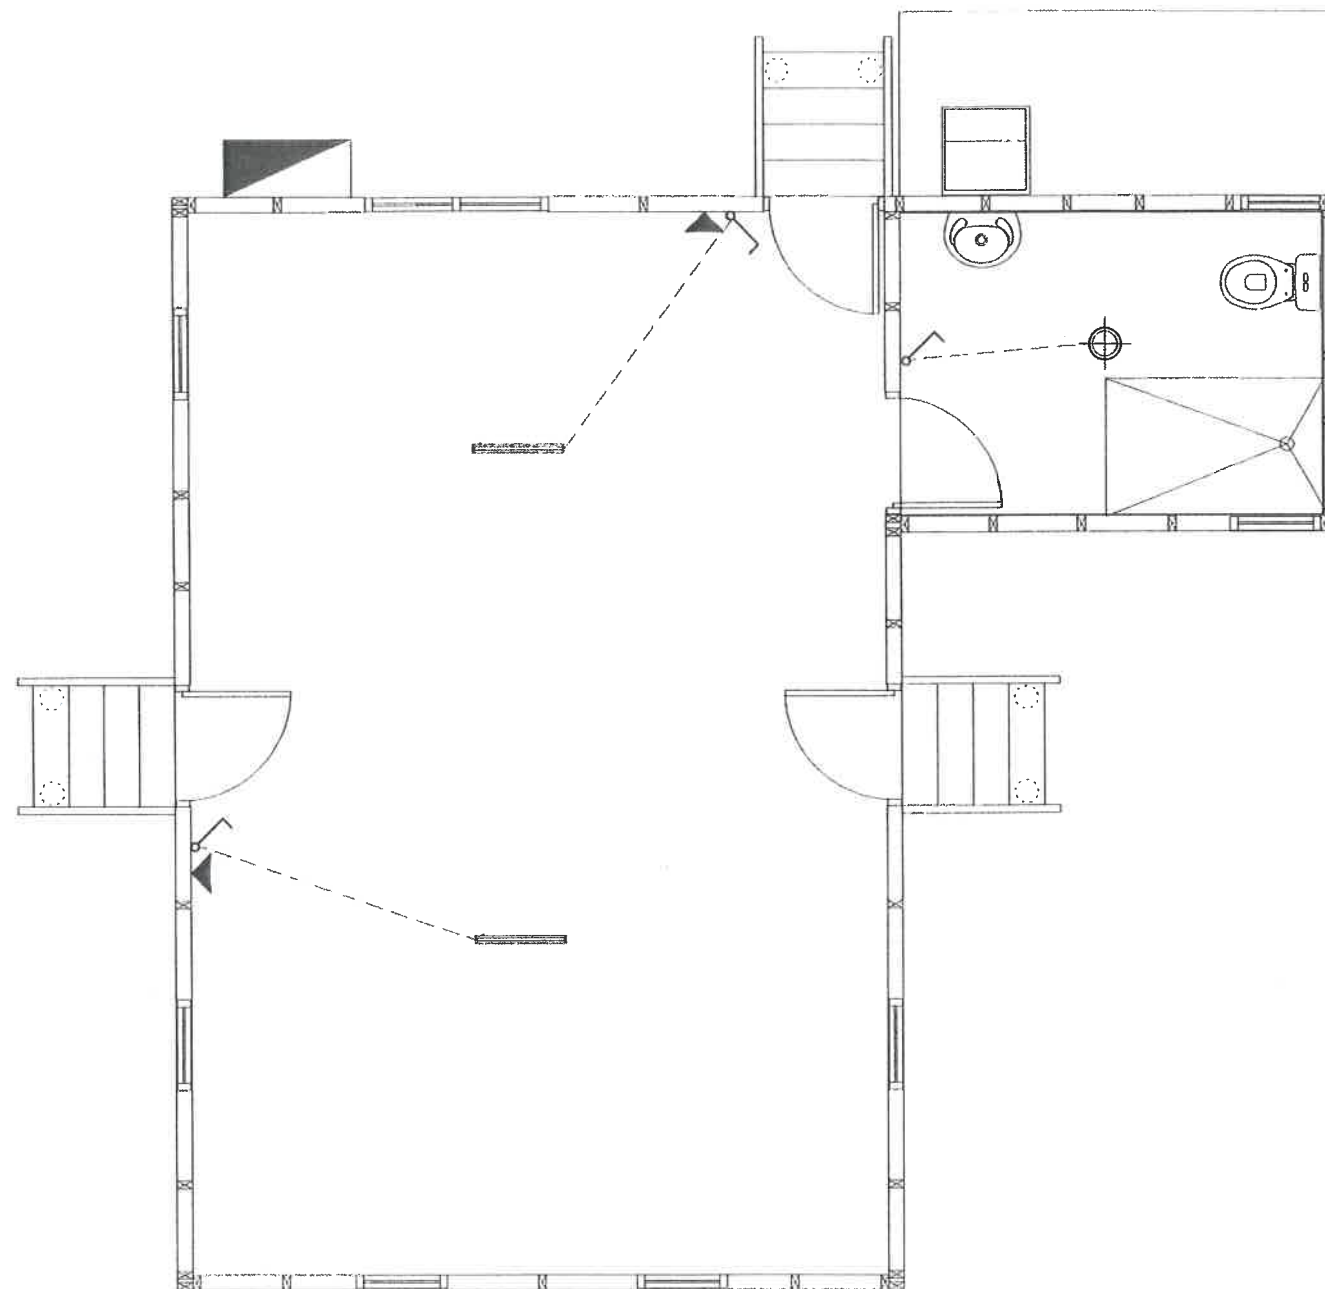

LEGEND

	MAIN SWITCH BOARD
	600MM TUBE LIGHT
	BATTEN HOLDER WITH BULB
	DOUBLE POWER POINT
	LIGHT SWITCH & WIRE

ELECTRICAL PLAN
scale 1:50@A3

I have checked the structural components shown on the drawing and certify that they are adequate for their intended purpose.
16/2/24
Job # 24-9
ARJUNESH CHAND (MEIE # 286)

Note:

1. The contractor/ builder shall notify the designer of any discrepancies prior to producing shop drawings and commencement of work on site.
2. All dimension's are in millimeter (mm). Figure dimensions shall take precedence over scaled dimensions and larger scale drawings shall take precedence over scaled drawings.
3. Copyright: Ministry of Rural & Maritime Development and Disaster Management. All Rights Reserved.



Project Title
STANDARD 7.2m X 4.8m OPEN DESIGN TIMBER FRAMED HOUSE WITH 2.9m X 2.2m TOILET, BATHROOM & LAUNDRY AREA.
Regional House
1 Knolly Street
P.O Box 2219
Govt. Bldg
Suva.

Ministry Of Rural & Maritime Development and Disaster Management
Rural Housing Assistance Unit

Phone: (679) 3313 400
Fax: (679) 3684 973
Suva.




Designed	RHA	Checked	HRHA
Drawn	RHA	Approved	HRHA

Date	FEB' 2024
Scale	AS SHOWN


Drawing Title	ELECTRICAL PLAN
Drawing Reference No.	4/15/1/5-1(REV. 1)

Sheet No.


E01

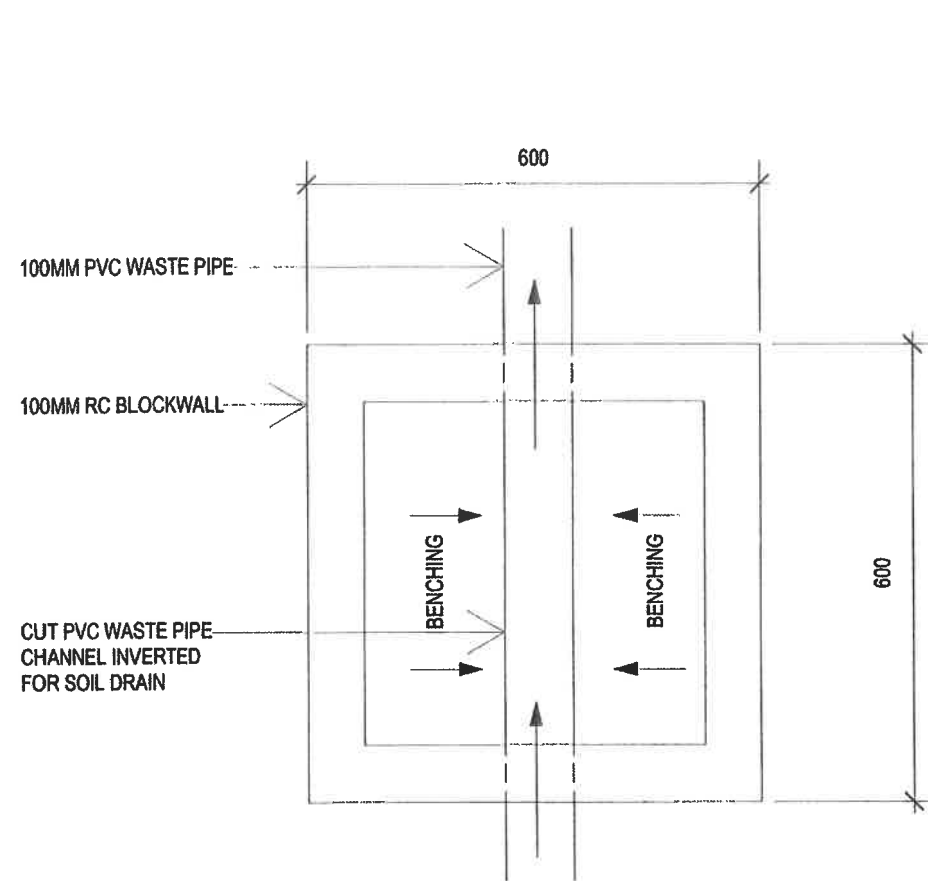


TYPICAL PLAN - INSPECTION CHAMBER
SCALE 1:10 @ A3

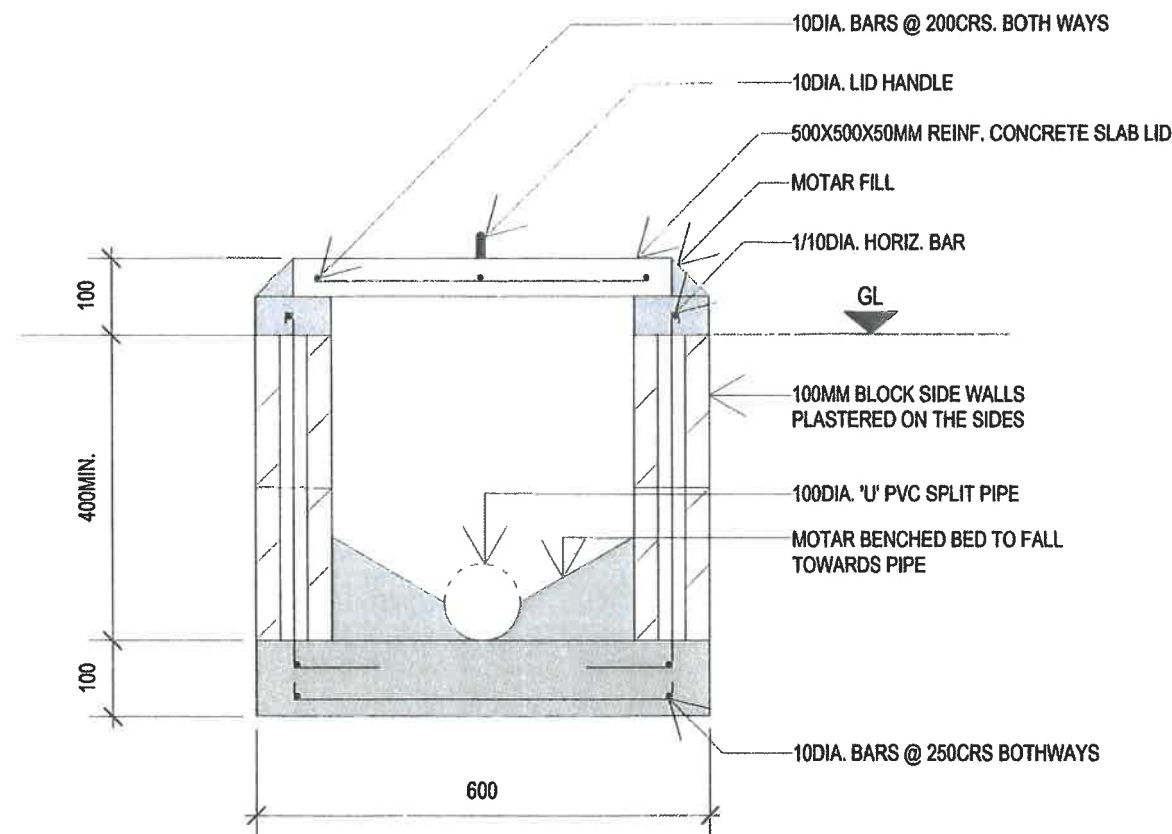

TYPICAL SECTION - INSPECTION CHAMBER
SCALE 1:10 @ A3

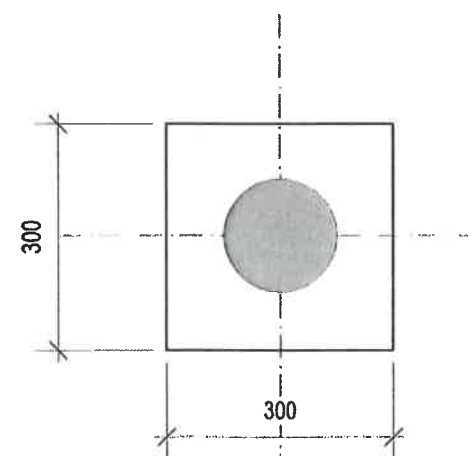

GULLY TRAP PLAN
SCALE 1:10 @ A3

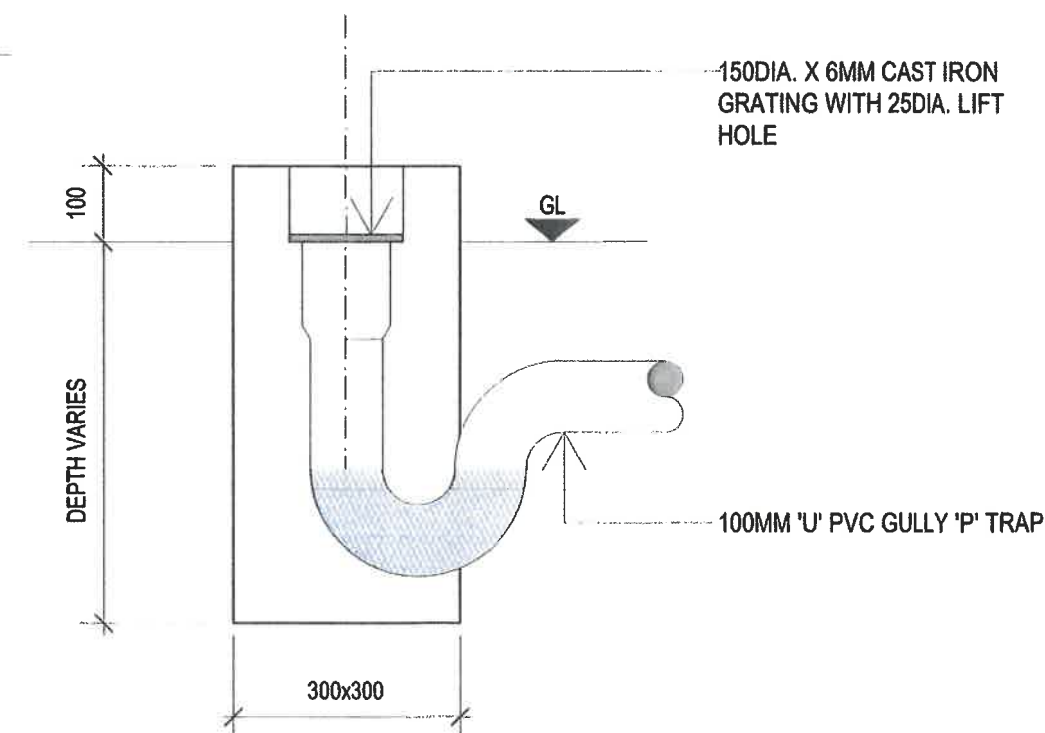

GULLY TRAP SECTION
SCALE 1:10 @ A3

I have checked the structural components shown on the drawing, and certify that they are adequate for their intended purpose.

16/2/24
Job #24-9
ABHINAV CHAND (MEIE # 206)

- Note:
- The contractor/ builder shall notify the designer of any discrepancies prior to producing shop drawings and commencement of work on site.
 - All dimensions are in millimeter (mm). Figure dimensions shall take precedence over scaled dimensions and larger scale drawings shall take precedence over scaled drawings.
 - Copyright: Ministry of Rural & Maritime Development and Disaster Management. All Rights Reserved.



Project Title
STANDARD 7.2m X 4.8m OPEN DESIGN TIMBER FRAMED HOUSE WITH 2.9m X 2.2m TOILET, BATHROOM & LAUNDRY AREA.


Regional House
1 Knolly Street
P.O Box 2219
Govt. Bldg
Suva.

Ministry Of Rural & Maritime Development and Disaster Management
Rural Housing Assistance Unit


Phone: (679) 3313 400
Fax: (679) 3684 973
Suva.




Designed RHA	Checked HRHA	Date FEB' 2024	Drawing Title PLUMBING DETAILS
Drawn RHA	Approved HRHA	Scale AS SHOWN	Drawing Reference No. 4/15/1/5-1 (REV. 1)
			Sheet No. P01

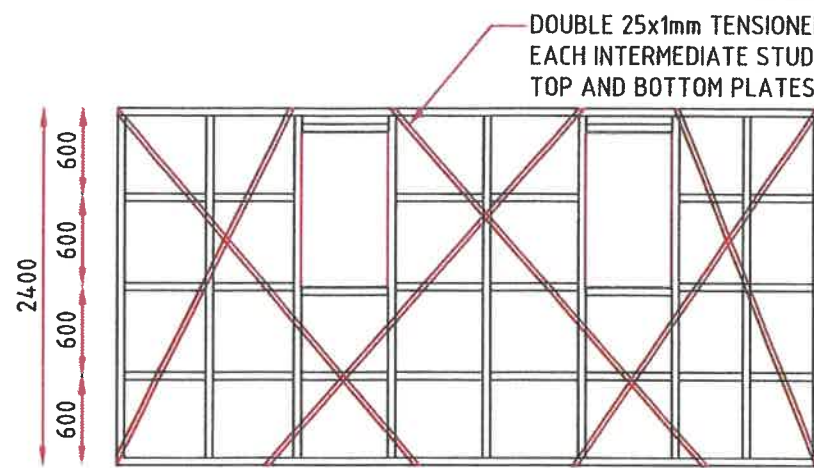


WALL ELEVATION ALONG GRIDLINE C
SCALE 1:50

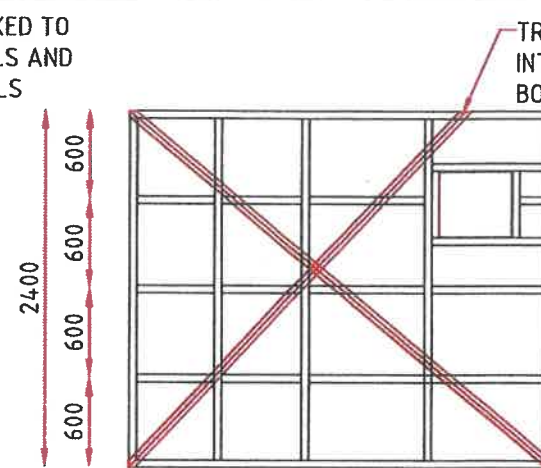


WALL ELEVATION ALONG GRIDLINE B
SCALE 1:50

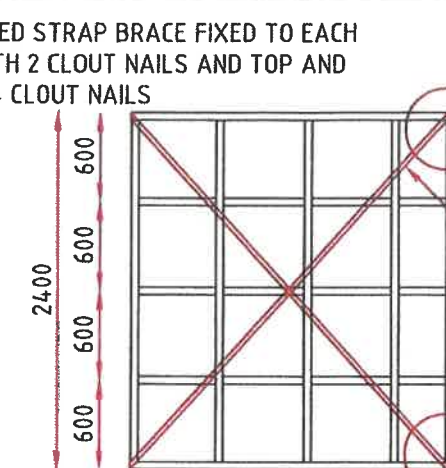


WALL ELEVATION ALONG GRIDLINE 3
SCALE 1:50

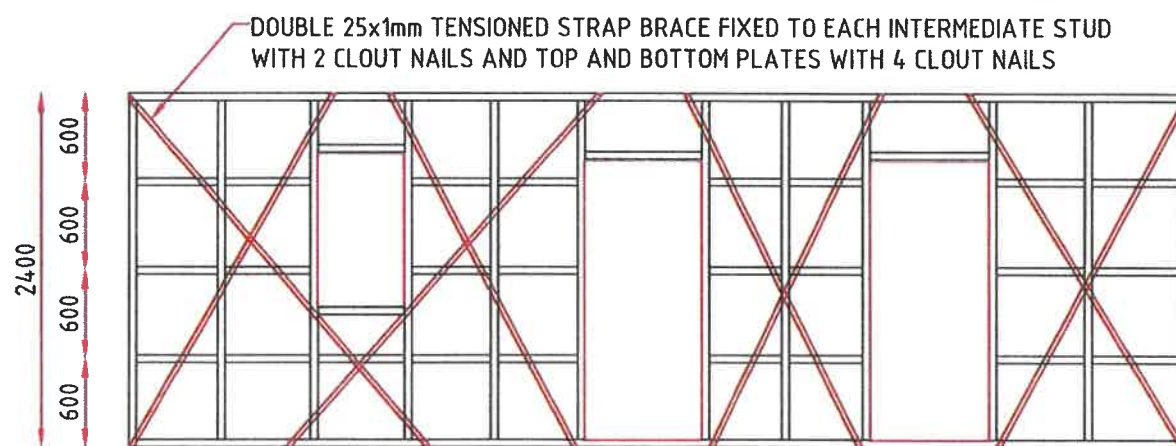

WALL ELEVATION ALONG GRIDLINE 2
SCALE 1:50

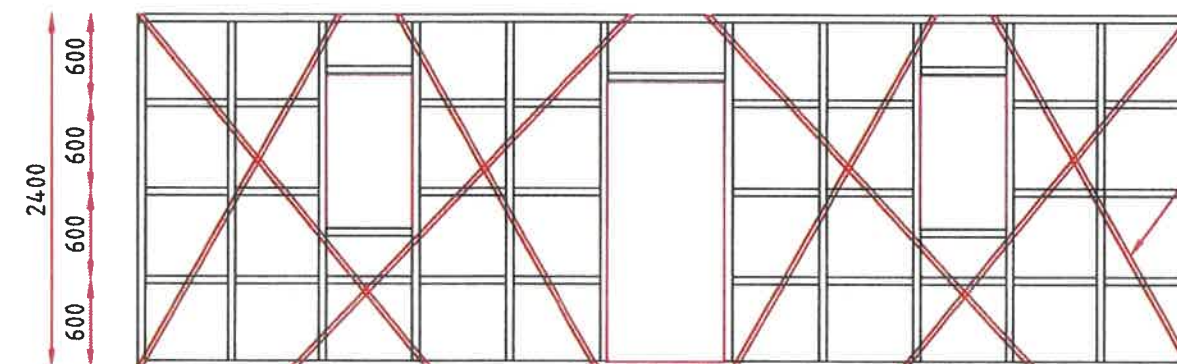

WALL ELEVATION ALONG GRIDLINE 1
SCALE 1:50

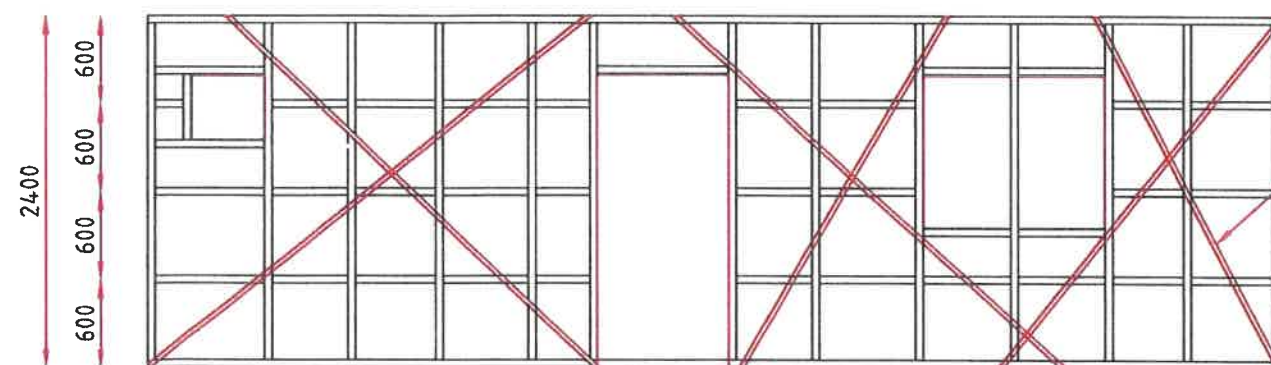

WALL ELEVATION ALONG GRIDLINE A
SCALE 1:50

DOUBLE 25x1mm TENSIONED STRAP BRACE FIXED TO EACH INTERMEDIATE STUD WITH 2 CLOUT NAILS AND TOP AND BOTTOM PLATES WITH 4 CLOUT NAILS

I have checked the structural components shown on the drawing and certify that they are adequate for their intended purpose
16/12/24
Job # 24-9
ABHINAV CHAND (MFE # 286)

NOTE:
BRACING STRAPS TO BE LOOPED AROUND AND NAILED TO TOP PLATE WHILE OTHER END TO BE TENSIONED AND NAILED TO BOTTOM PLATE PRIOR TO NAILING ALL HOLES. BRACING STRAPS TO BE 20mm APART.

CHAND ENGINEERING CONSULTANTS LTD
CONSULTING ENGINEERS & PROJECT MANAGERS
28A Vidal Avenue, Vatuwaqa, Suva
P.O.Box 11708, Suva, Fiji. Ph 3380599 Fax 3380599
Email: chand@chand-engineering.com

COPYRIGHT
THE INFORMATION CONTAINED IN THIS DOCUMENT IS THE PROPERTY OF CHAND ENGINEERING CONSULTANTS LTD. UNLAWFUL USE OR DUPLICATION IN PART OR IN WHOLE OF THE DOCUMENT WITHOUT THE PRIOR WRITTEN CONSENT OF CHAND ENGINEERING CONSULTANTS LTD SHALL BE ACCOUNTED AS INFRINGEMENT OF COPYRIGHT

CLIENT:
MINISTRY OF RURAL AND MARITIME DEVELOPMENT AND NATIONAL DISASTER MANAGEMENT


PROJECT:
RURAL HOUSING UNIT

DRAWING TITLE:
BRACING DETAILS

REV	BY	DATE

DESIGNED	DESIGN CHK	SCALE
AAC		1:50
DRAFTED	DRAFTING CHK	ISSUE DATE
RRP		16/02/2024
PROJECT NO.	DRAWING SHT	REVISION
2024-09	S-04	

25x1mm TENSIONED STRAP BRACE FIXED TO EACH INTERMEDIATE STUD WITH 2 CLOUT NAILS AND TOP AND BOTTOM PLATES WITH 4 CLOUT NAILS

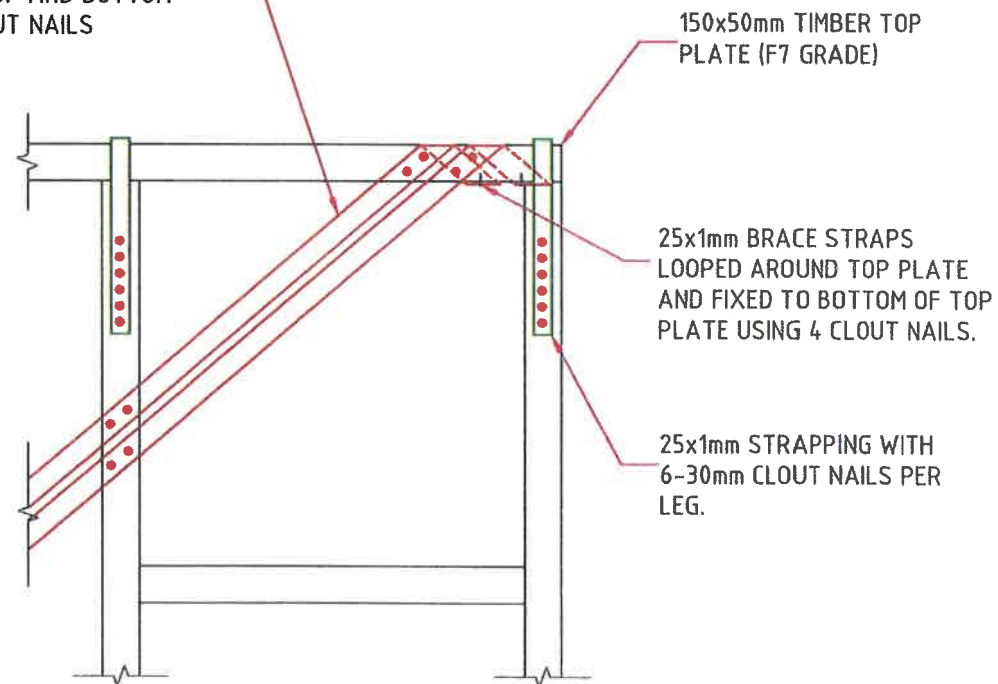


DETAIL 1
SCALE 1:20
S-04

150x50mm TIMBER TOP PLATE (F7 GRADE)

25x1mm BRACE STRAPS LOOPED AROUND TOP PLATE AND FIXED TO BOTTOM OF TOP PLATE USING 4 CLOUT NAILS.

25x1mm STRAPPING WITH 6-30mm CLOUT NAILS PER LEG.

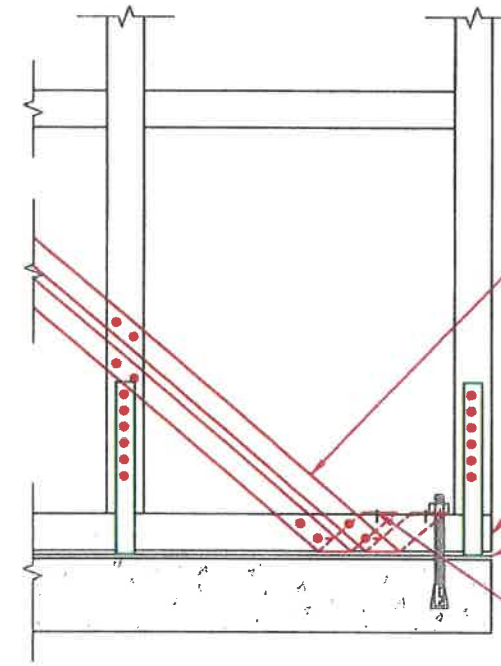

25x1mm TENSIONED STRAP BRACE FIXED TO EACH INTERMEDIATE STUD WITH 2 CLOUT NAILS AND TOP AND BOTTOM PLATES WITH 4 CLOUT NAILS

150x50mm TIMBER BOTTOM PLATE (F7 GRADE)

MALTHOID TO BE LAID IN BETWEEN TIMBER BOTTOM PLATE AND CONCRETE SLAB

25x1mm BRACE STRAPS LOOPED AROUND BOTTOM PLATE AND FIXED TO TOP OF BOTTOM PLATE USING 4 CLOUT NAILS.

DETAIL 2
SCALE 1:10
S-04

I have checked the structural components shown on the drawing and certify that they are adequate for their intended purpose.
16/2/24
Job # 24-9
ALVINE SUTCHAND (M.E. # 256)



CHAND ENGINEERING CONSULTANTS LTD
CONSULTING ENGINEERS & PROJECT MANAGERS
29A Vidal Avenue, Vatuvaqa, Suva
P.O.Box 11708, Suva, Fiji. Ph 3380589 Fax 3380589
Email: achand@chand-engineering.com

COPYRIGHT
THE INFORMATION CONTAINED IN THIS DOCUMENT IS THE COPYRIGHT OF CHAND ENGINEERING CONSULTANTS LTD. UNLAWFUL USE OR DUPLICATION IN PART OR IN WHOLE OF THE DOCUMENT WITHOUT THE PRIOR WRITTEN CONSENT OF CHAND ENGINEERING CONSULTANTS LTD SHALL BE ACCOUNTED AS INFRINGEMENT OF COPYRIGHT

CLIENT:
MINISTRY OF RURAL AND MARITIME DEVELOPMENT AND NATIONAL DISASTER MANAGEMENT

PROJECT:
RURAL HOUSING UNIT

DRAWING TITLE:
BRACING DETAILS

REV	BY	DATE

DESIGNED	DESIGN CHK	SCALE
A.A.C		1:50
DRAFTED	DRAFTING CHK	ISSUE DATE
RRP		16/02/2024
PROJECT NO.	DRAWING SHT	REVISION
2024-09	S-05	



**MINISTRY OF RURAL AND MARITIME DEVELOPMENT AND
DISASTER MANAGEMENT**

RURAL HOUSING ASSISTANCE

MATERIAL LIST FOR STD 7.2M X 4.8M OPEN HOUSE + 2.8M X 2.2M BATHROOM + 2.8M X 1.2M LAUNDRY

No.	Item	Qty	Unit
A	Preliminary & General		
1	50x50 Boxing Timber @ 6m	2	Ingth
2	75x25 Boxing Timber @ 6m	5	Ingth
3	200x25 Boxing Timber @ 6m	2	Ingth
4	75mm Wire Nails	1	kg
5	100mm Wire Nails	1	kg
6	75mm x 100m Caution Tape	1	no.

B	Below Ground - Floor		
1	200dia. H4 Pine Post @ 1.8m	18	no.
2	150dia. H4 Pine Post @ 1m - Step Post	6	no.
3	12dia. Rod Spikes @6m	4	Ingth
4	Black Visqueen Plastic	1	roll
5	150mm Thick STD Conc. Block	140	no.
6	12dia. Deformed Bars @ 6m	30	Ingth
7	10dia. Deformed Bars @ 6m	13	Ingth
8	665 Mesh @ 6mx2.4m	1	sht
9	Black Binding Wire	5	kg
10	Cement @ 40kg bag	28	bag
11	River Gravel @20kg bag	130	bag
12	150X50 H3 TRT Timber Bearer @ 6m	6	Ingth
13	100x50 H3 TRT Timber Floor Joist @ 6m	15	Ingth
14	100x25 H3 TRT T&G Floor Boards @ 6m	85	Ingth
15	12dia. Dyna Bolts	6	no.
16	12dia. Threaded Rods @ 3m	4	Ingth
17	12dia. Glav. Nuts c/w Metal Washer	48	no.
18	6" Galv. Nails	6	kg
19	4" Galv. Nails	10	kg
20	2" Galv. Nails	14	kg
21	32mm Galv. Cloat Nails	15	kg
22	31x1.8mm Pre-holed Galv. Strap @ 27m coil	6	coil

C	Floor - Roof		
1	100x50 H3 TRT Timber B/Plate, Studs, Noggings & T/Plate @6m	45	lngh
2	165x65 H3 Profiled Cill Board @ 6m	1	lngh
3	150x25 H3 TRT Timber Weatherboard @ 6m	130	lngh
4	150x50 H3 TRT Timber Rafters @ 6m	14	lngh
5	75x50 H3 TRT Timber Purlins @ 6m	18	lngh
6	100x50 H3 TRT Timber Bottom Chord @ 6m	8	lngh
7	235 x 30 H3 TRT DRD Timber Fascia Board @ 6m	6	lngh
8	50 x 50 H3 TRT Timber Ceiling Noggs @ 6m	15	lngh
9	90 x 20 H3 TRT DRD Timber Eave Battens	40	lngh
10	31x1.8mm Pre-holed Galv. Strap @ 27m coil	15	coil
11	26G Colorbond Corrugated Roofing @3.5m	27	sht
12	24G Galvanised Ridge Capping @ 1.8m	6	lgth
13	24G Galvanised Barge Flashing @ 1.8m	10	lgth
14	Type 17 Roof Screws c/w rubber washer	960	no.
15	Single Sided Sisalation Foil @ 40m	1	roll
16	Damp Proof Membrane @ 100mm	1	roll
17	12 dia. Anchor Bolt c/w Nut	25	no.
18	6mm Int. plyboard Ceiling Board	15	sht
19	6mm Cement Board	9	sht
20	Gripset Water Proofing @ 15lt bkt	1	bkt
21	Gripset Elastoproof B50 Joint Band @ 50m	1	roll
22	100x25 H3 TRT T&G Lining @ 6m (Door Material)	12	lngh
23	150mm zinc plated Tee Hinge	8	pair
24	150mm zinc plated pad bolt	5	no.
25	7 Blade Louvre Frame	7	no.
26	3 Blade Louvre Frame	2	no.
27	610x150x5mm Clear Louvre Blade	60	no.
28	12dia. Threaded Rods @ 3m	12	lngh
29	12dia. Nuts c/w Metal Washers	160	no.
30	6" Galv. Nails	4	kg
31	4" Galv. Nails	15	kg
32	3" Galv. Nails	10	kg
33	2" Galv. Nails	15	kg
34	20mm Self Tapping Screws @ 500pc PKT	1	pkt
35	Clear Silicone	1	tubes
36	250x50 H3 TRT Timber Steps Material @ 6m	2	lngh

D	Electrical		
1	Power Point Wire	15	m
2	Light Wire	15	m
3	Switch Wire	15	m
4	Light Switch	3	no.
5	Single Power Point	1	no.
6	Double Power Point	1	no.
7	Mounting Block	4	no.
8	6G x 25mm Self Tapping Screw	100	pc
9	2' LED tube light frame c/w tube	2	no.
10	LED bulb holder c/w bulb	1	no.
11	No. 3 wiring clip	1	pkt
12	No. 4 wiring clip	1	pkt
13	14x12 Meter Box	1	no.
14	35 Main Switch	1	no.
15	16amps ELCB	1	no.
16	10amps ELCB	1	no.
17	4 Pole ELCB Cover	1	no.
18	7 Holed Neutral Link	1	no.
19	20mm PVC Elbow	5	no.
20	20mm PVC Conduit Pipe	1	lngh
21	6mm PVC Green	1	m
22	6mm PVC Red	1	m
23	6mm PVC Black	1	m
24	20mm Saddle	8	no.
25	Earth Rod	1	no.
26	Light Clip	1	no.
27	5S32 Machine Square Nut	10	pc
28	Silver Spray Paint	1	can
29	19mm x 10m Insulation Tape	1	no.

E	Plumbing		
1	1/2" PVC Water Pipe	3	Ingth
2	40dia. PVC Waste Pipe	1	Ingth
3	100dia. PVC Waste Pipe	3	Ingth
4	1/2" Brass Stopcork	2	no.
5	1/2" Brass Long Neck Laundry Tap	1	no.
6	1/2" CP Hand Basin Tap	1	no.
7	Shower Rose	1	no.
8	Selected Hand Basin	1	no.
9	Toliet Set c/w Seat	1	no.
10	Single Concrete Wash Tub	1	no.
11	50mm PVC Waste S&P Trap	1	no.
12	40mm PVC Waste S-Trap	1	no.
13	PVC WasteR/Socket 50x40mm	1	no.
14	1/2" PVC Plain Socket	6	no.
15	1/2" PVC Plain Elbow	6	no.
16	1/2" PVC Plain 'T'	6	no.
17	1/2" PVC P/T Socket	3	no.
18	1/2" PVC Pipe Clip	12	no.
19	40mm PVC Plain Socket	6	no.
20	40mm PVC Plain Elbow	6	no.
21	40mm PCS Plain 'T'	2	no.
22	40mm floor grating	1	no.
23	100mm PVC Waste Plain Socket	5	no.
24	100mm PVC Waste Plain 'T' Junction	1	no.
25	100mm PVC Waste Vent Cowl	1	no.
26	100mm PVC Pan Connector	1	no.
27	100mm PVC Waste Plain Elbow	2	no.
28	100mm PVC Waste Pipe Clip	3	no.
29	100mm 'U' PVC Gully 'P' Trap	1	no.
30	150dia. X 6mm Cast Iron Graiting	1	no.
31	1000lt Plastic Septic Tank	1	no.
32	80mm PVC Downpipe	3	Ingth
33	80mm PVC Downpipe Clip	12	no.
34	80mm PVC Downpipe Elbow	6	no.
35	PVC Rain Gutter @ 110x4m	6	Ingth
36	PVC End Cap Right @ 110	3	no.
37	PVC End Cap Left @ 110	3	no.
38	PVC Gutter Outlet @ 110	3	no.
39	PVC Gutter Bracket	30	no.
40	V-Tech PVC Glue @ 500ml	1	can
41	V-Tech PVC Glue @ 500ml	1	can

F	Finishing		
1	Pink Primer @ 4lt Can - Timber	8	can
2	Acrylic Undercoat @ 4lt Can - Blockwork	2	can
3	Acrylic Finishing Paint @ 4lt Can - Fascia Bd, Barge Bd & Base	4	can
4	Acrylic Finishing Paint @ 4lt Can - Doors	2	can
5	Acrylic Finishing Paint @ 4lt Can - Eave battens & Window Frame	3	can
6	Acrylic Finishing Paint @ 4lt Can - External Wall	4	can
7	Acrylic Finishing Paint @ 4lt Can - Internal Wall	4	can
8	Solid Floor Stain @ 4lt Can - Floor	3	can
9	Varnish @ 4lt Can - Floor	3	can
10	Paving Paint @ 4lt Can - Wet Area Floor	1	can
11	100mm Paint Brush	2	no.
12	75mm Paint Brush	2	no.
13	50mm Paint Brush	2	no.
14	Roller & Tray Set	1	set